




Date: % date
 Scale: % scale

Details of the Northern Plot Line and offsets to existing Condominium Unit Corners at the Villa Madelline Resort, Plot No. 19-A, Est. Teague Bay, STX

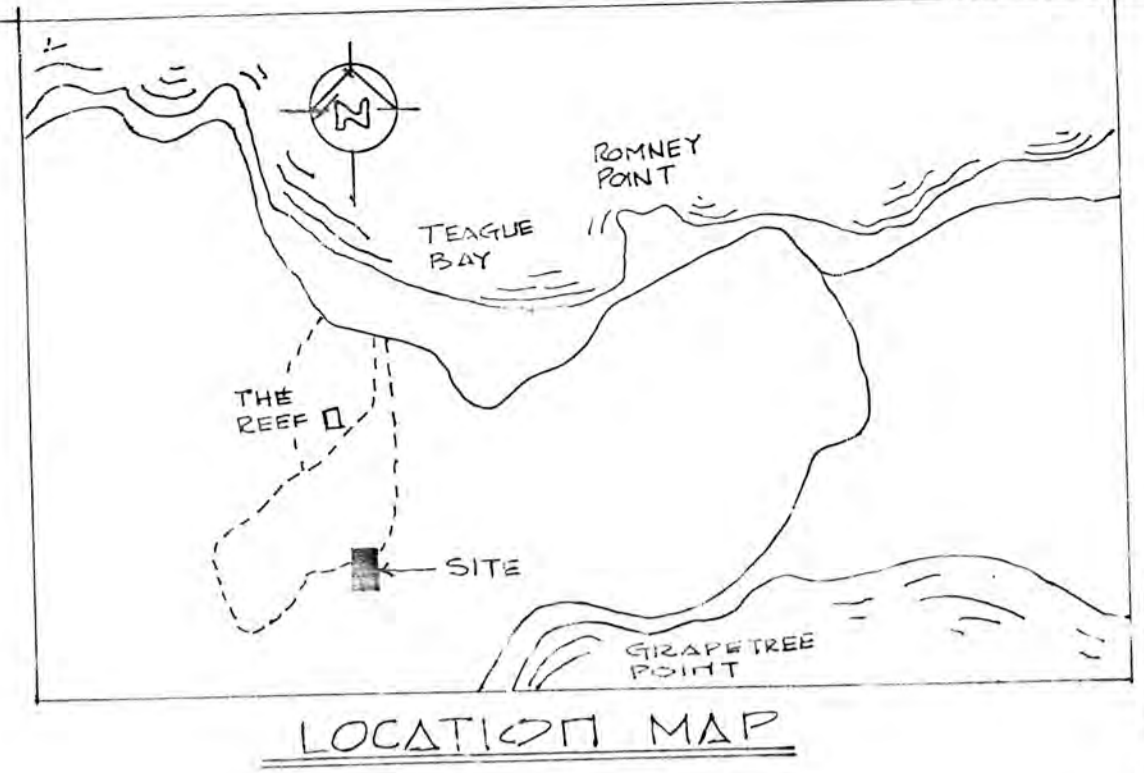


NOTES:

VILLA MADELEINE PHASE I, COMPRISED OF 19 A-1 (0.577 AC.) COLL. ABOVE
 19 A-2 (3.336 AC.) 19 A-2A (0.169 AC.)
 VILLA MADELEINE PHASE II, COMPRISED OF 19 A-3 (0.114 AC.)
 19 A-5 (1.831 AC.)
 REFER TO P.W.D. 3344


PL 17, NO. 19F

RE SURVEY PLOT NO 19-A ESTATE TEAGUE BAY, C'STER, STCR DATE: MAY 4TH 1998 SCALE: 1" = 40' PREPARED BY: JAMES BUCHANAN & EGIL KLIFT LS 226	
DPNR No. 3344-A	69

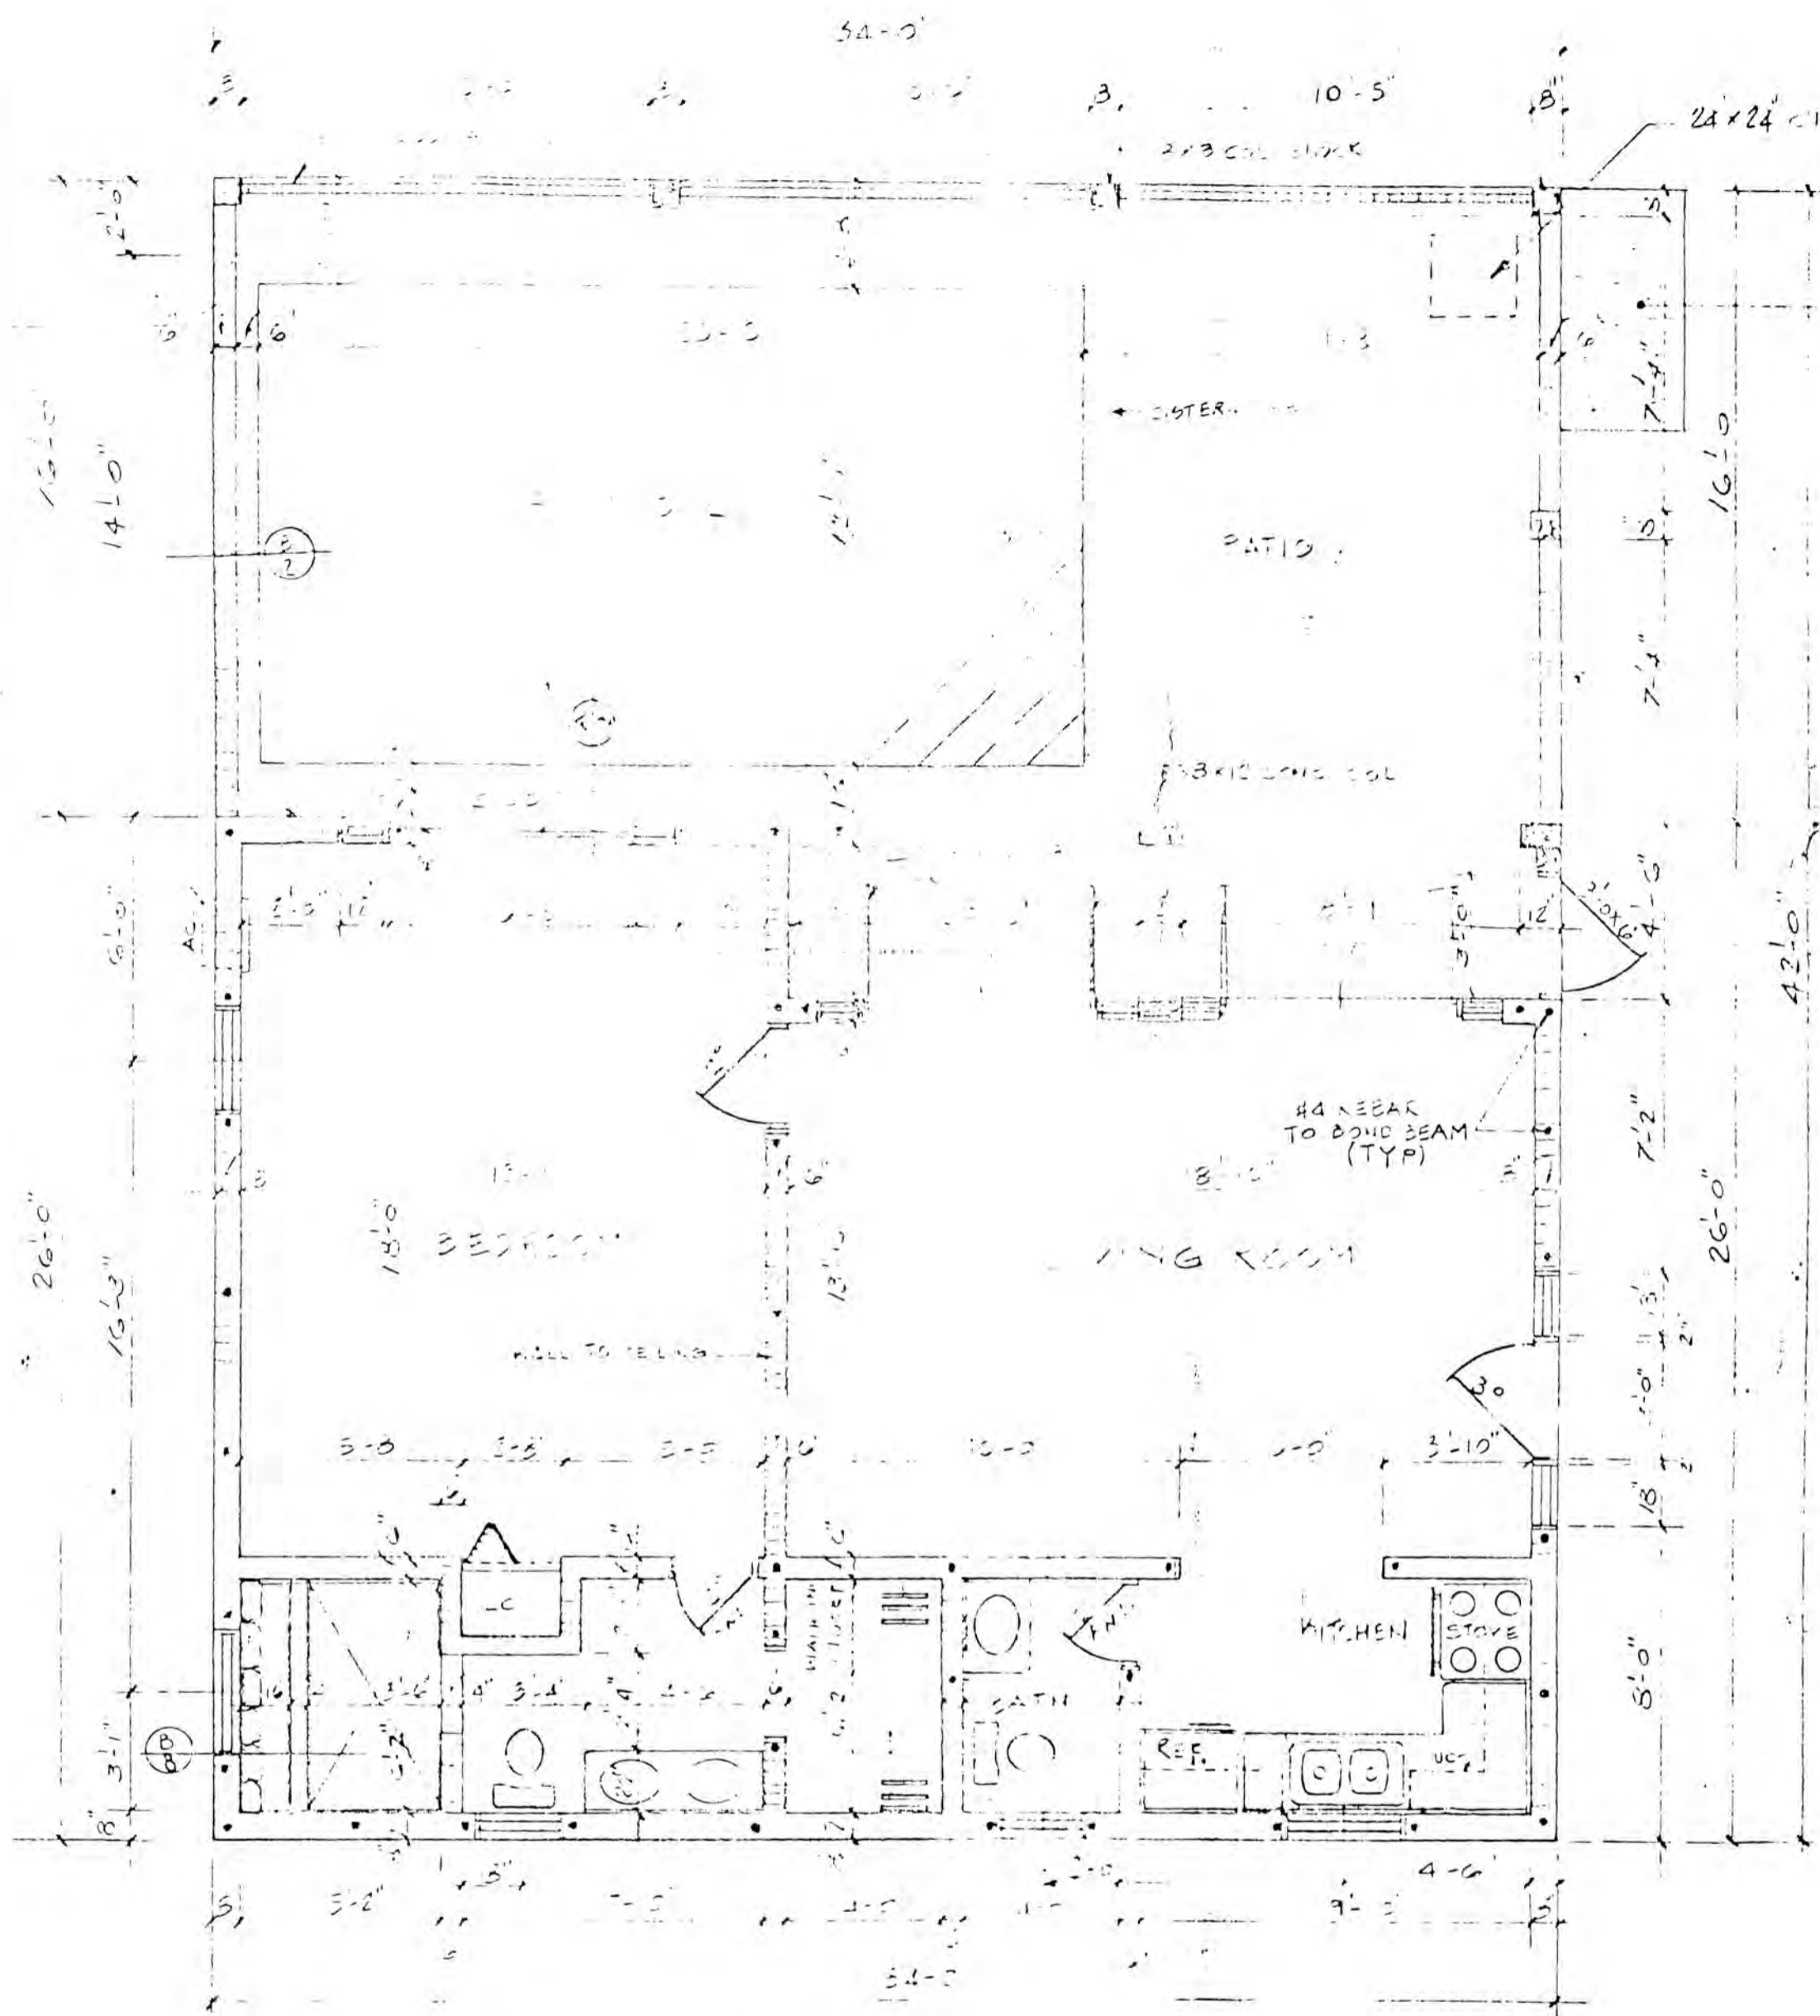


FLOOR PLAN

CONC. SLAB FOR POOL EQUIP & WATER PUMP

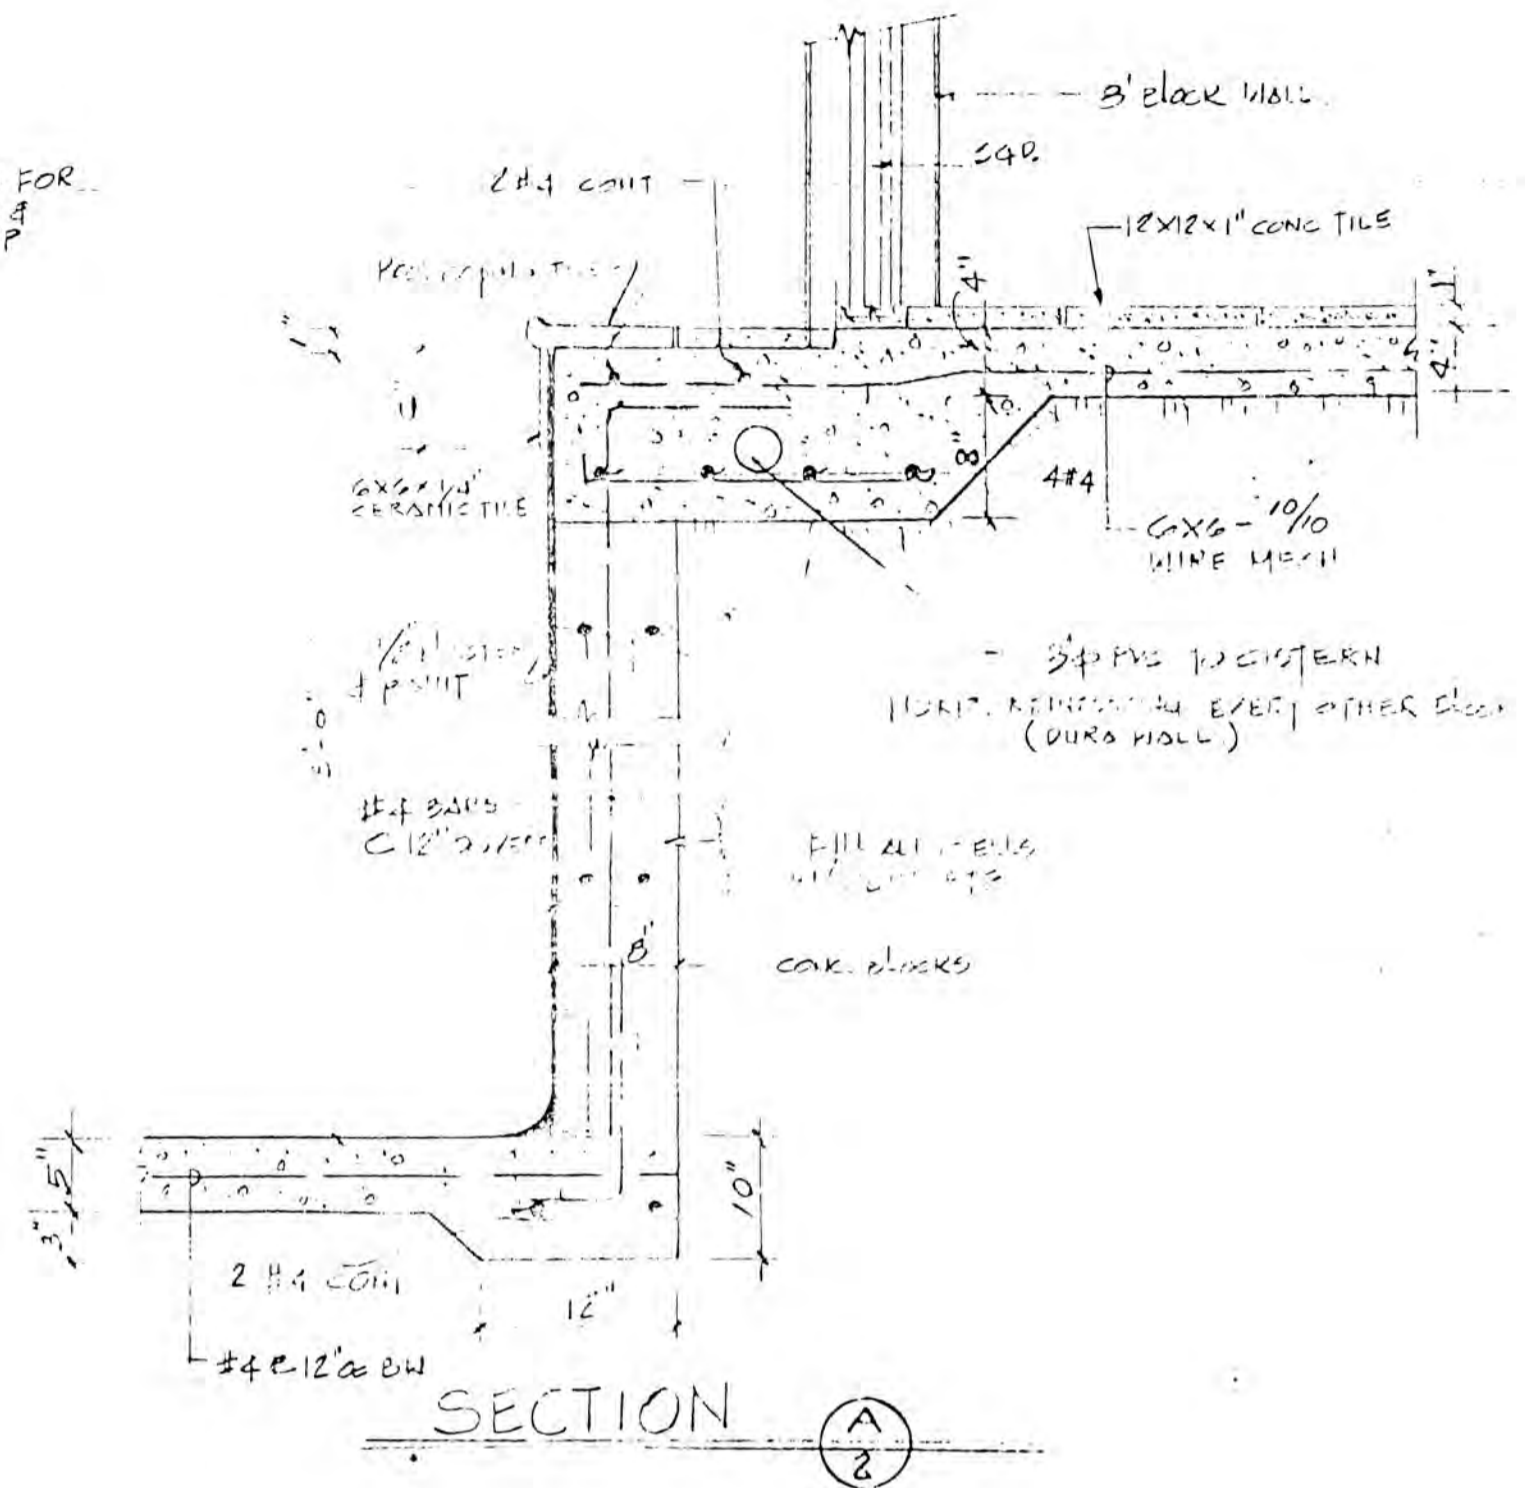

SECTION A-A

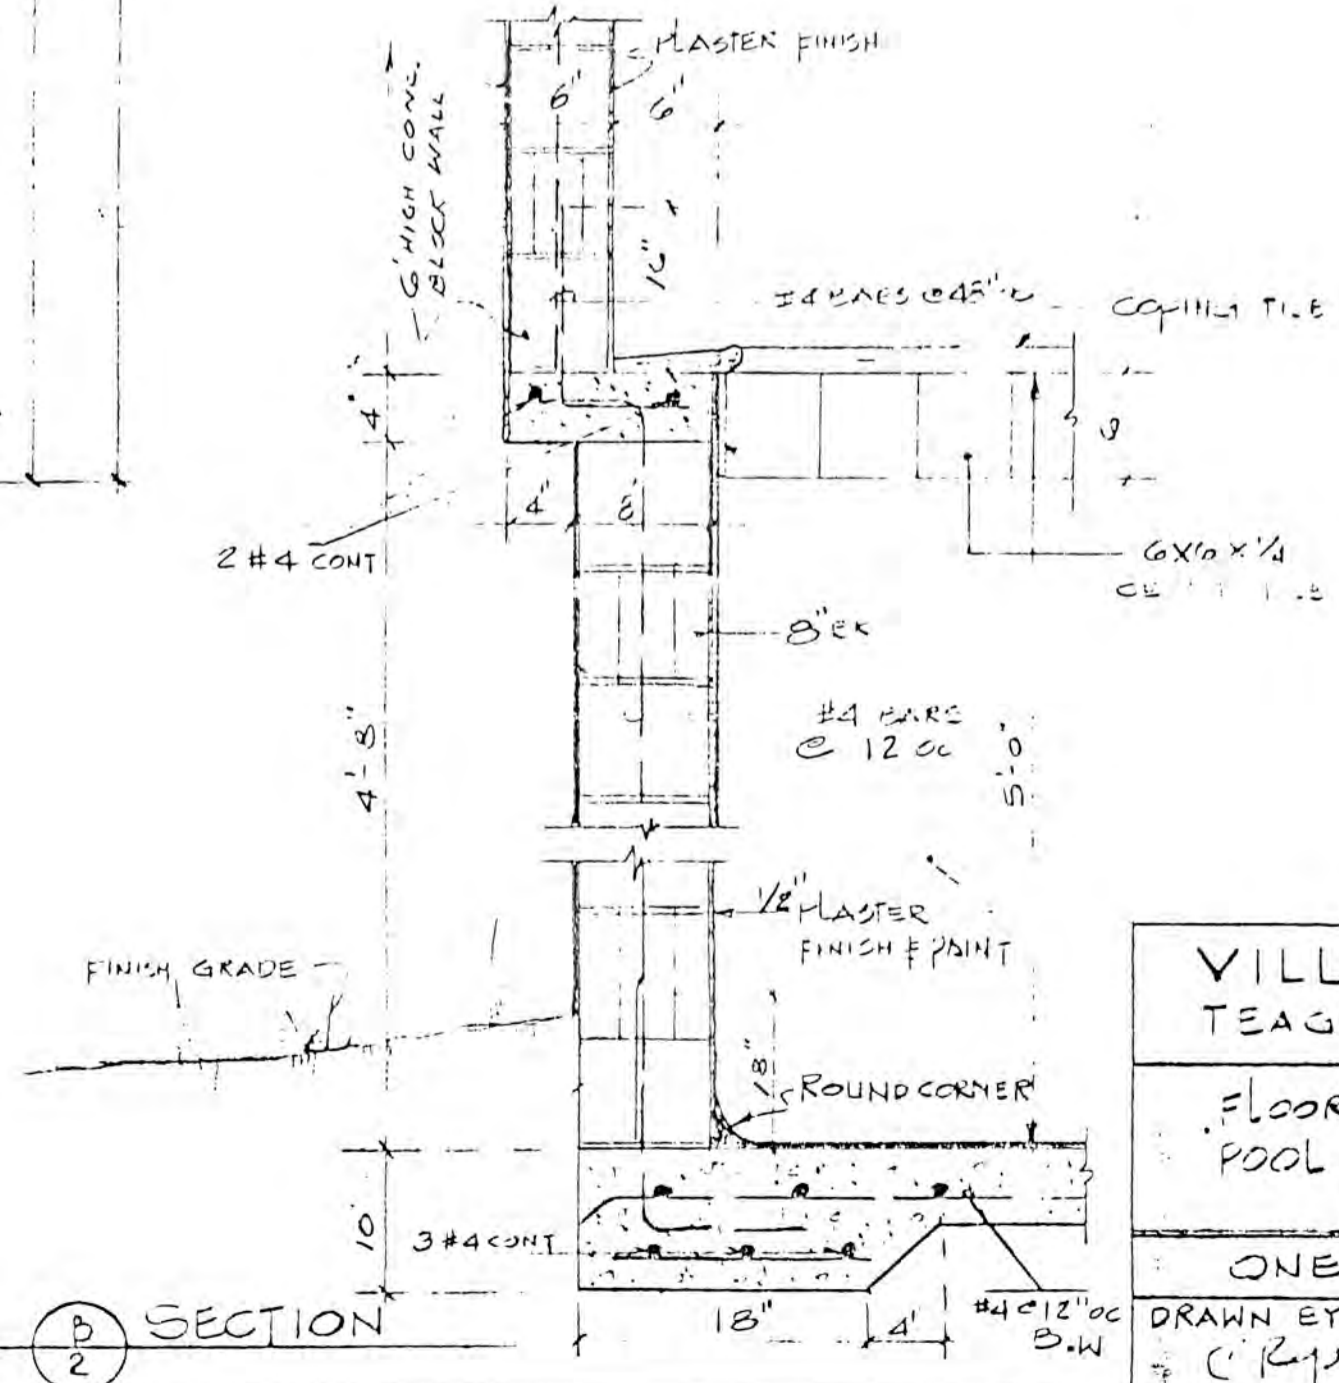


SECTION B-B




Permit 454-87


VILLA MADELEINE			
TEAGUE BAY		ST. CROIX	
FLOOR PLAN			
POOL SECTIONS			
ONE BEDROOM CONDOMINIUM			
DRAWN BY:	DATE:	SCALE:	SHEET NO.
C. R. [Signature]		AS SHOWN	4 OF 11

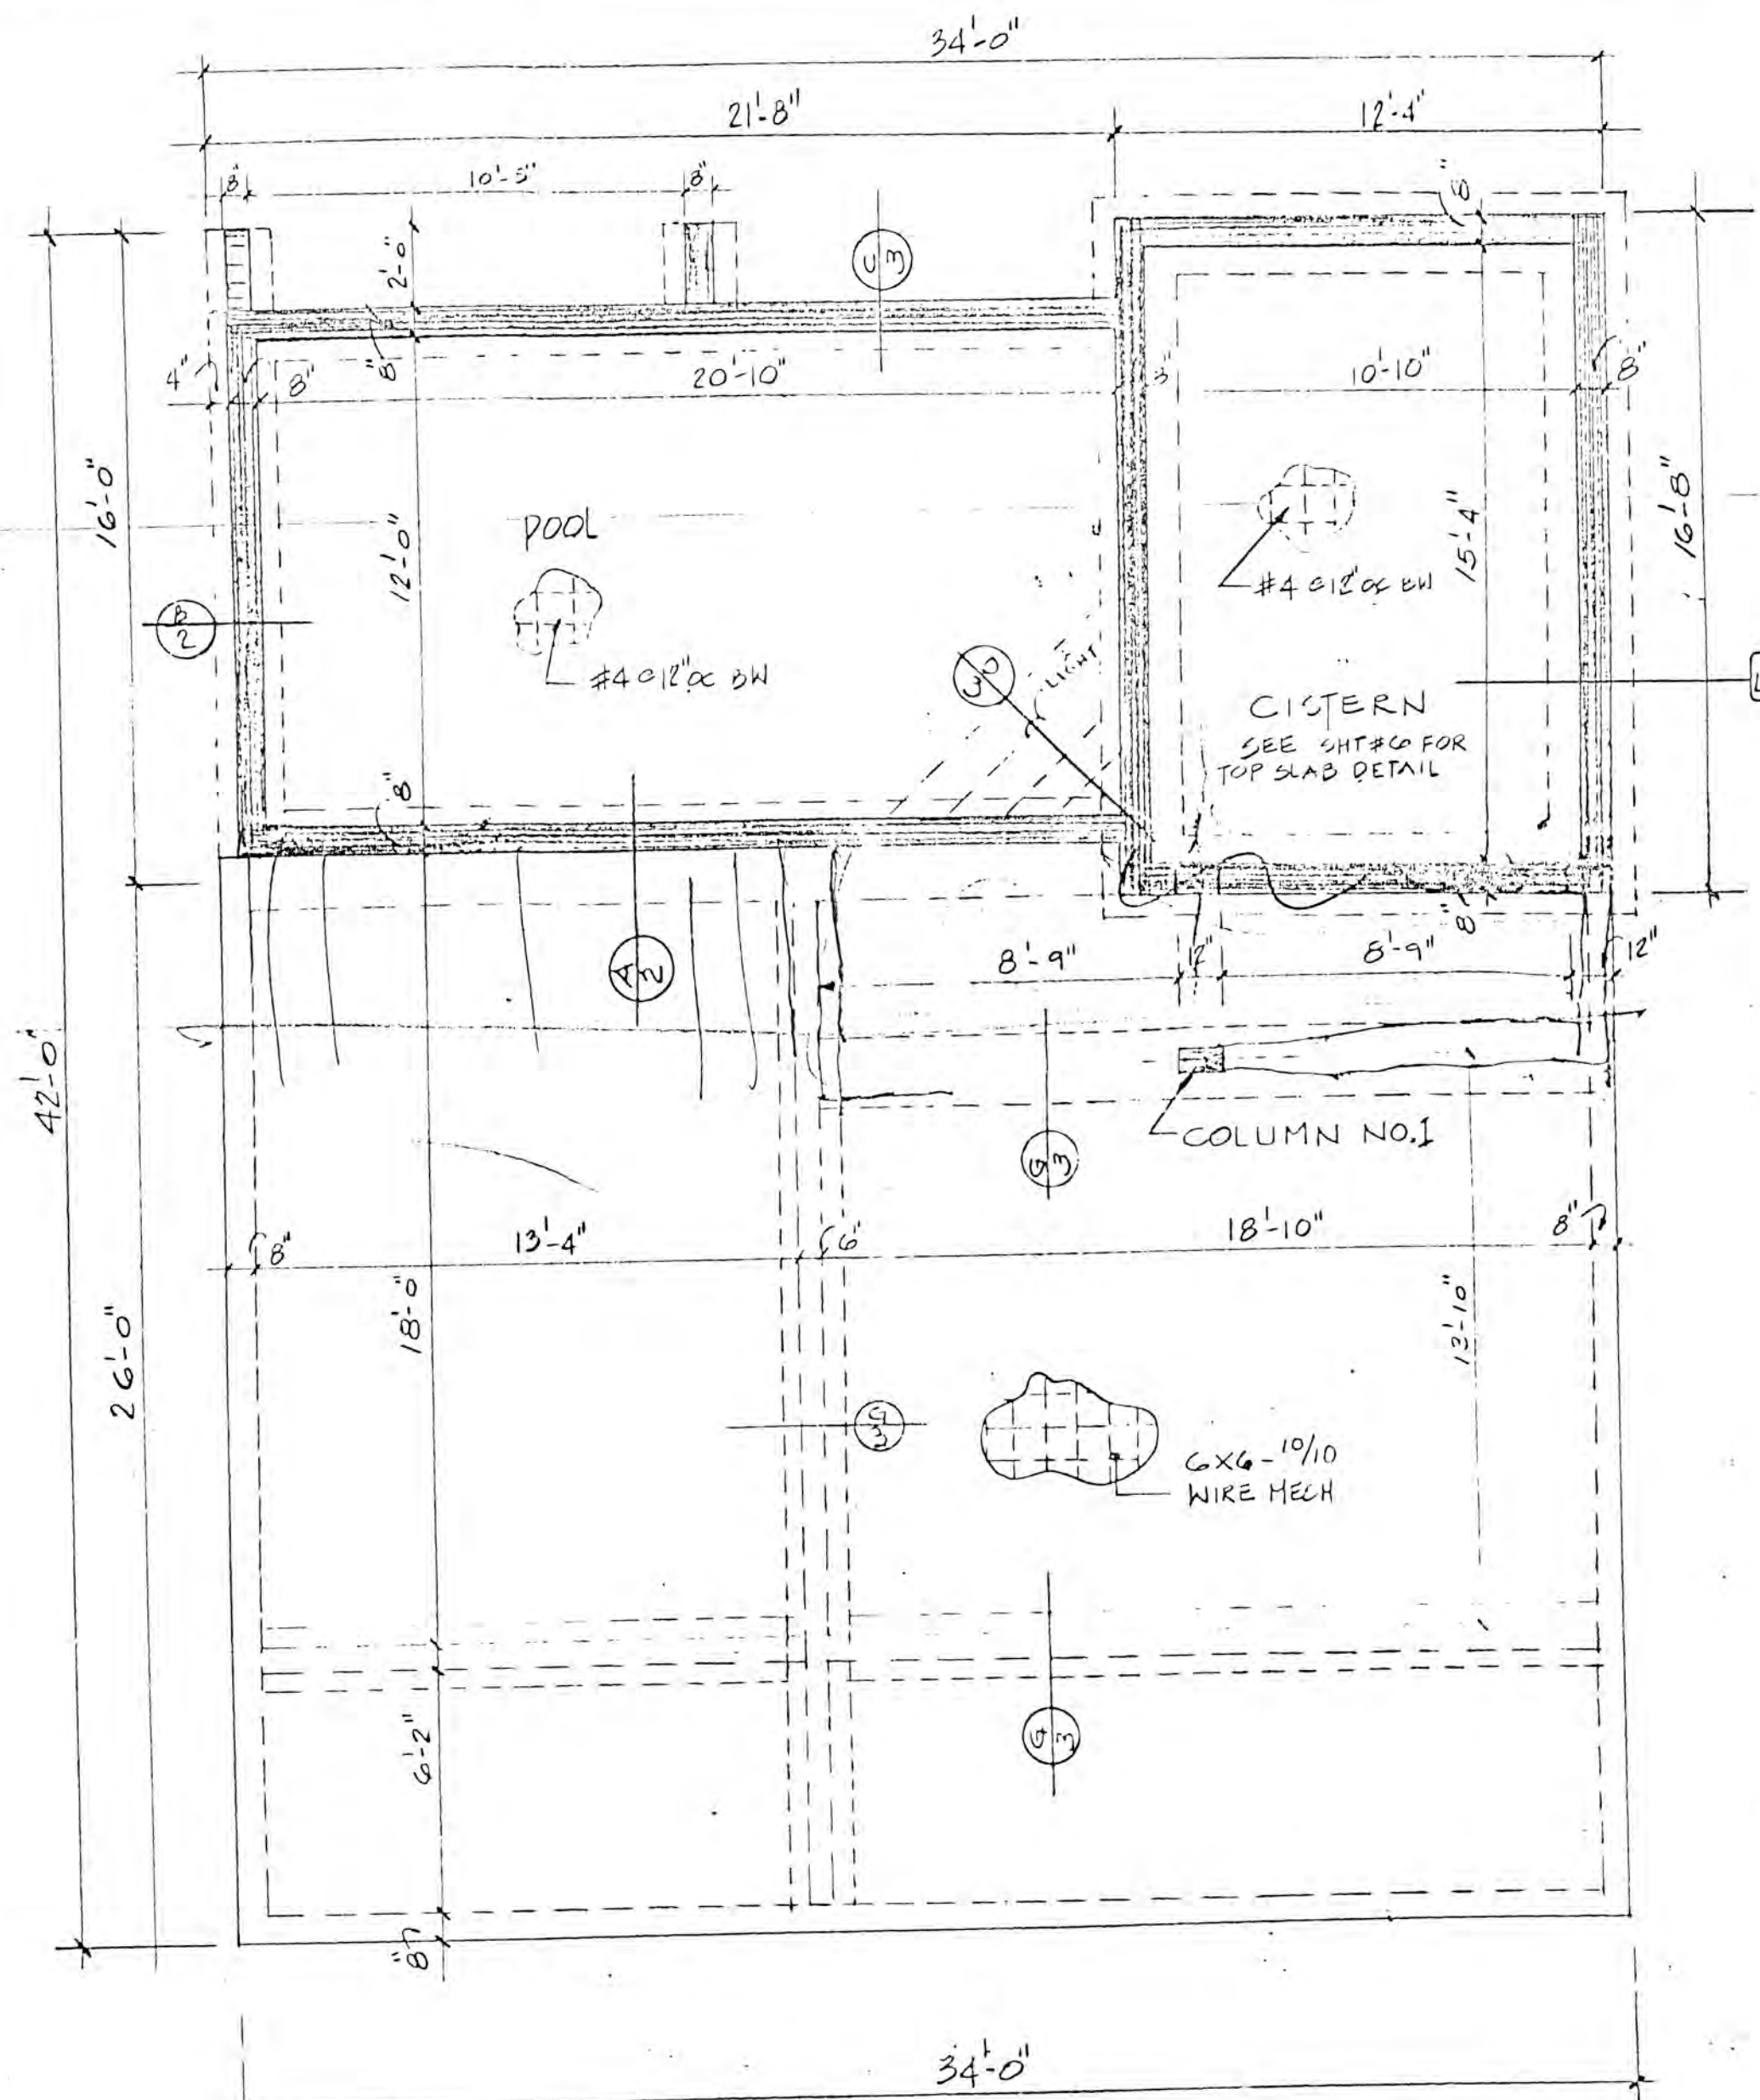


FOUNDATION PLAN
 Scale: 1/4" = 1'-0"

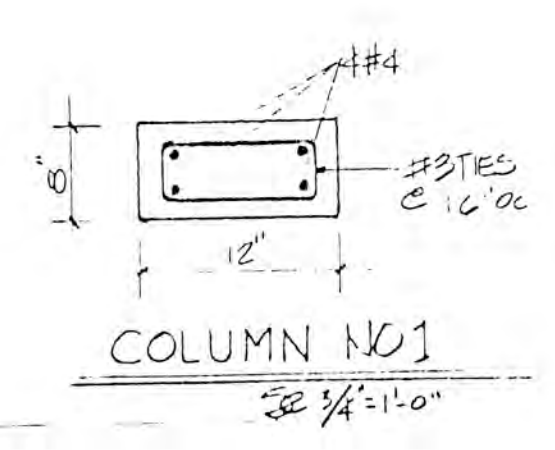

COLUMN NO. 1
 Scale: 3/4" = 1'-0"

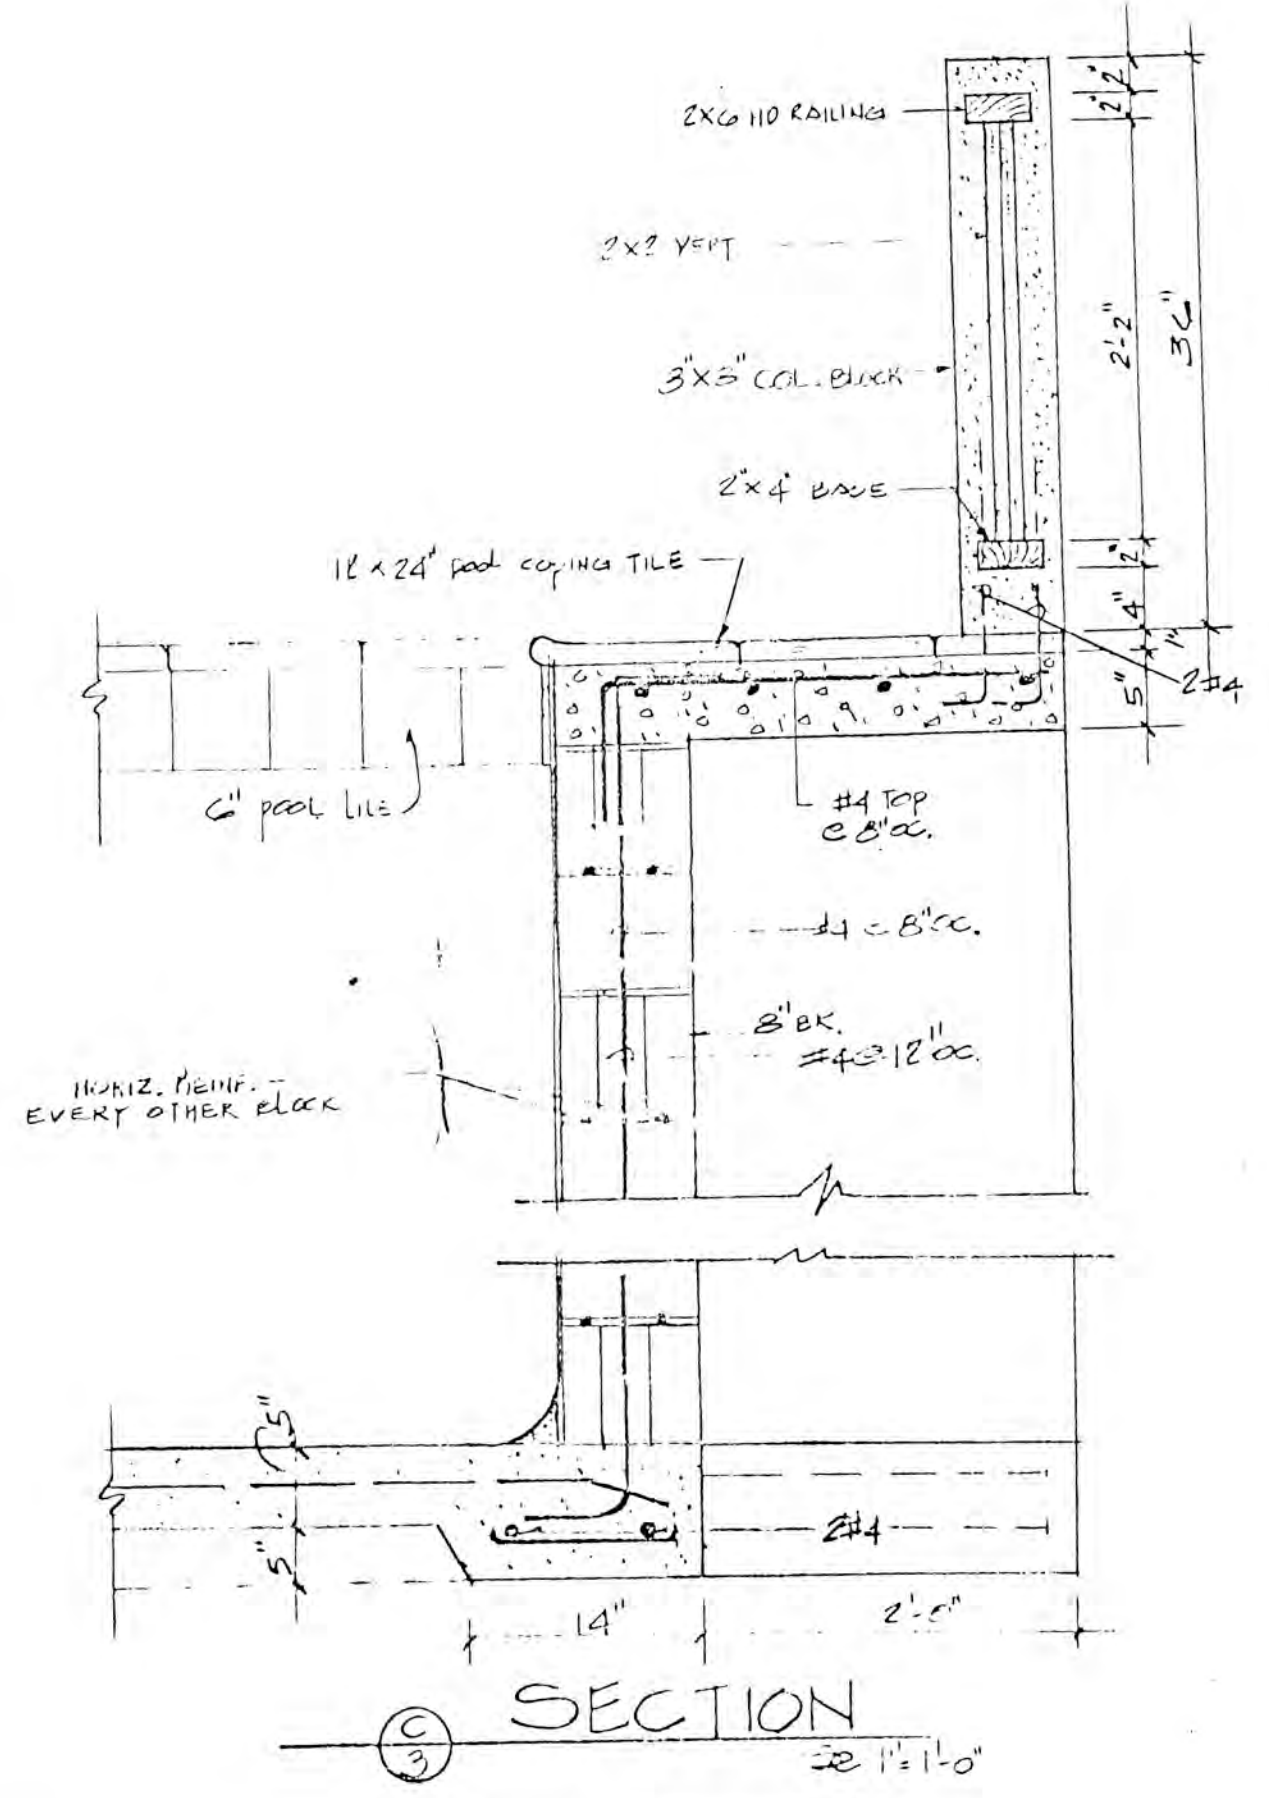

SECTION C-C
 Scale: 1" = 1'-0"

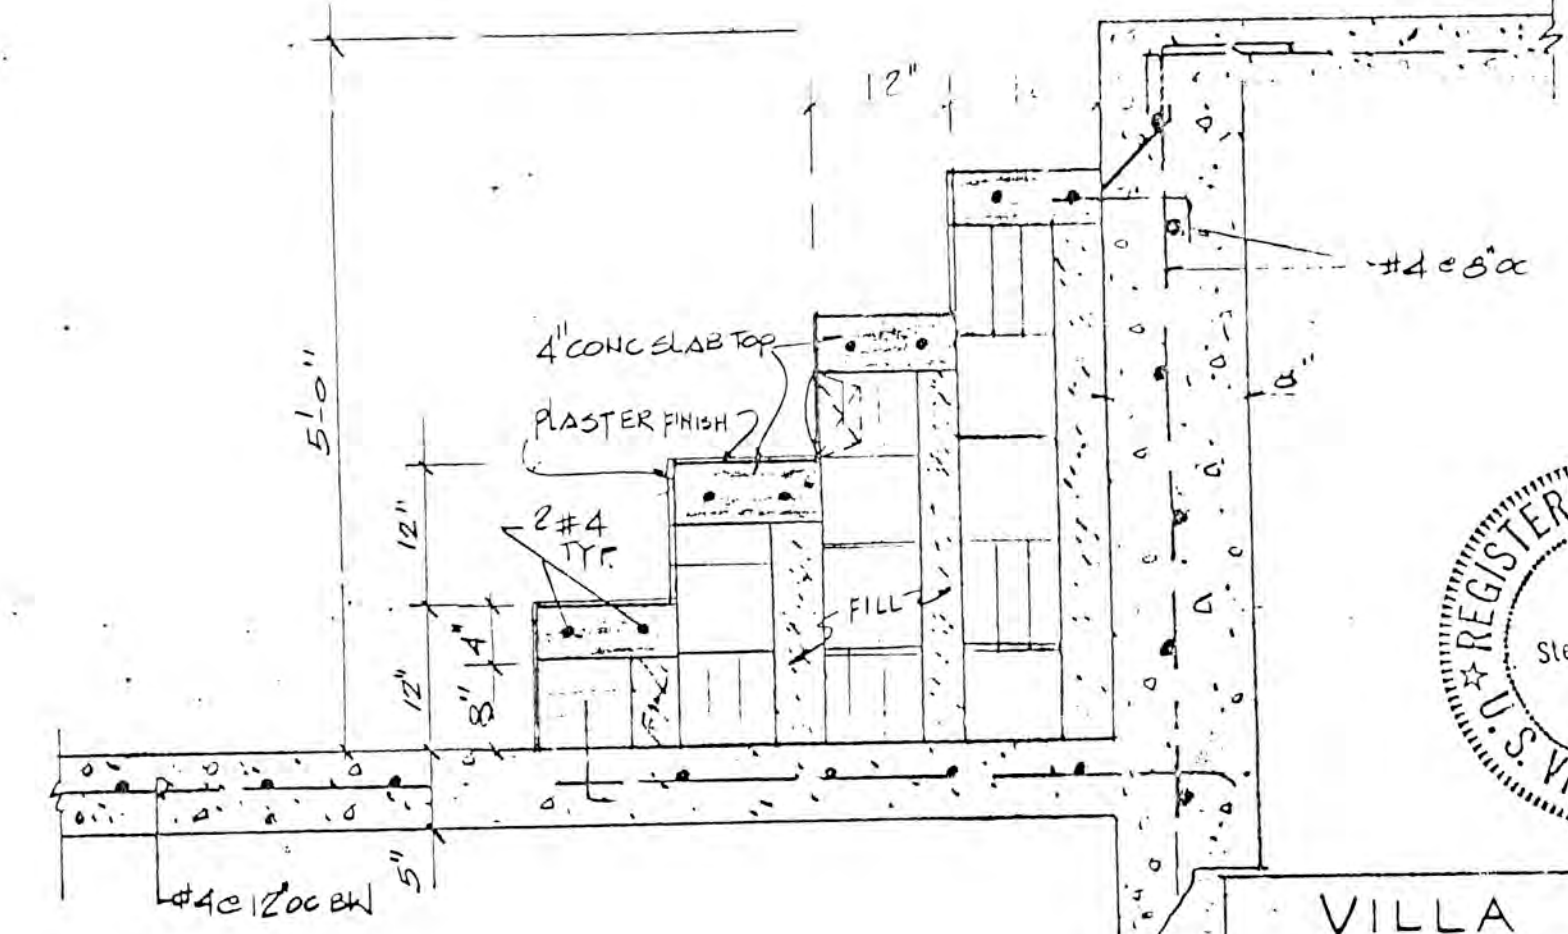


SECTION D-D
 Scale: 3/4" = 1'-0"




**VILLA MADELEINE
 TEAGUE BAY ST. CROIX**

ONE BEDROOM CONDOMINIUM			
DRAWN BY CR	DATE:	SCALE	SHEET NO. 5 of 11

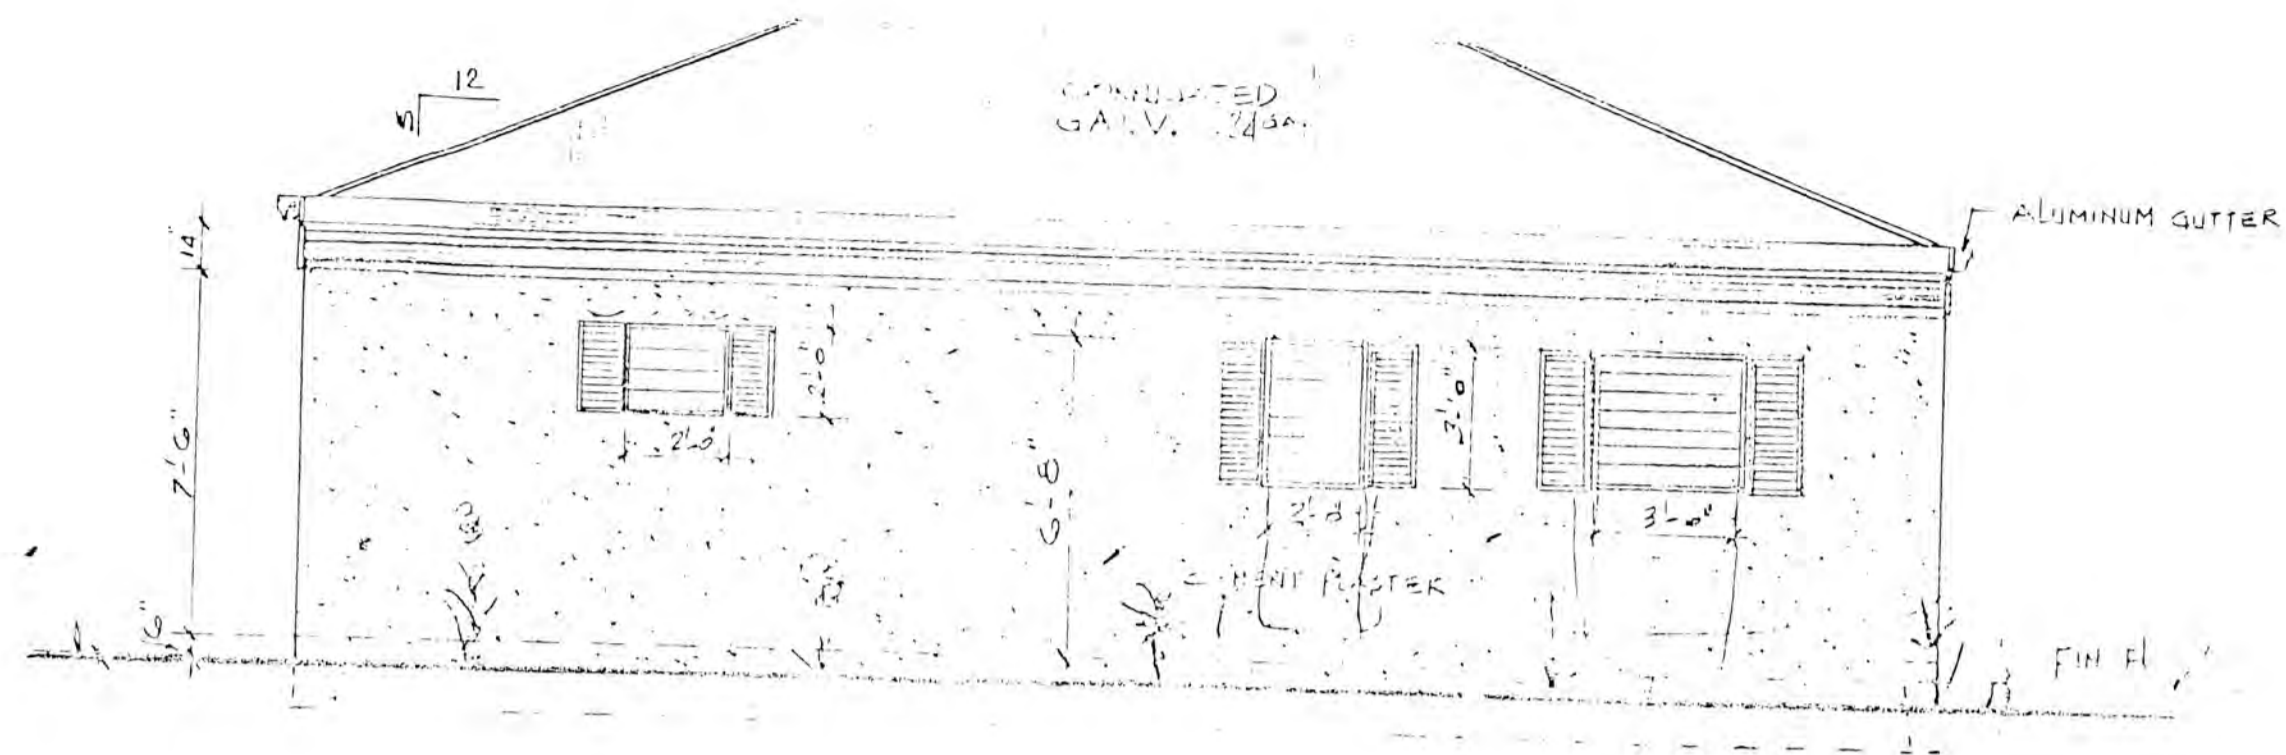


SOUTH ELEVATION
SC 1/4"=1'-0"

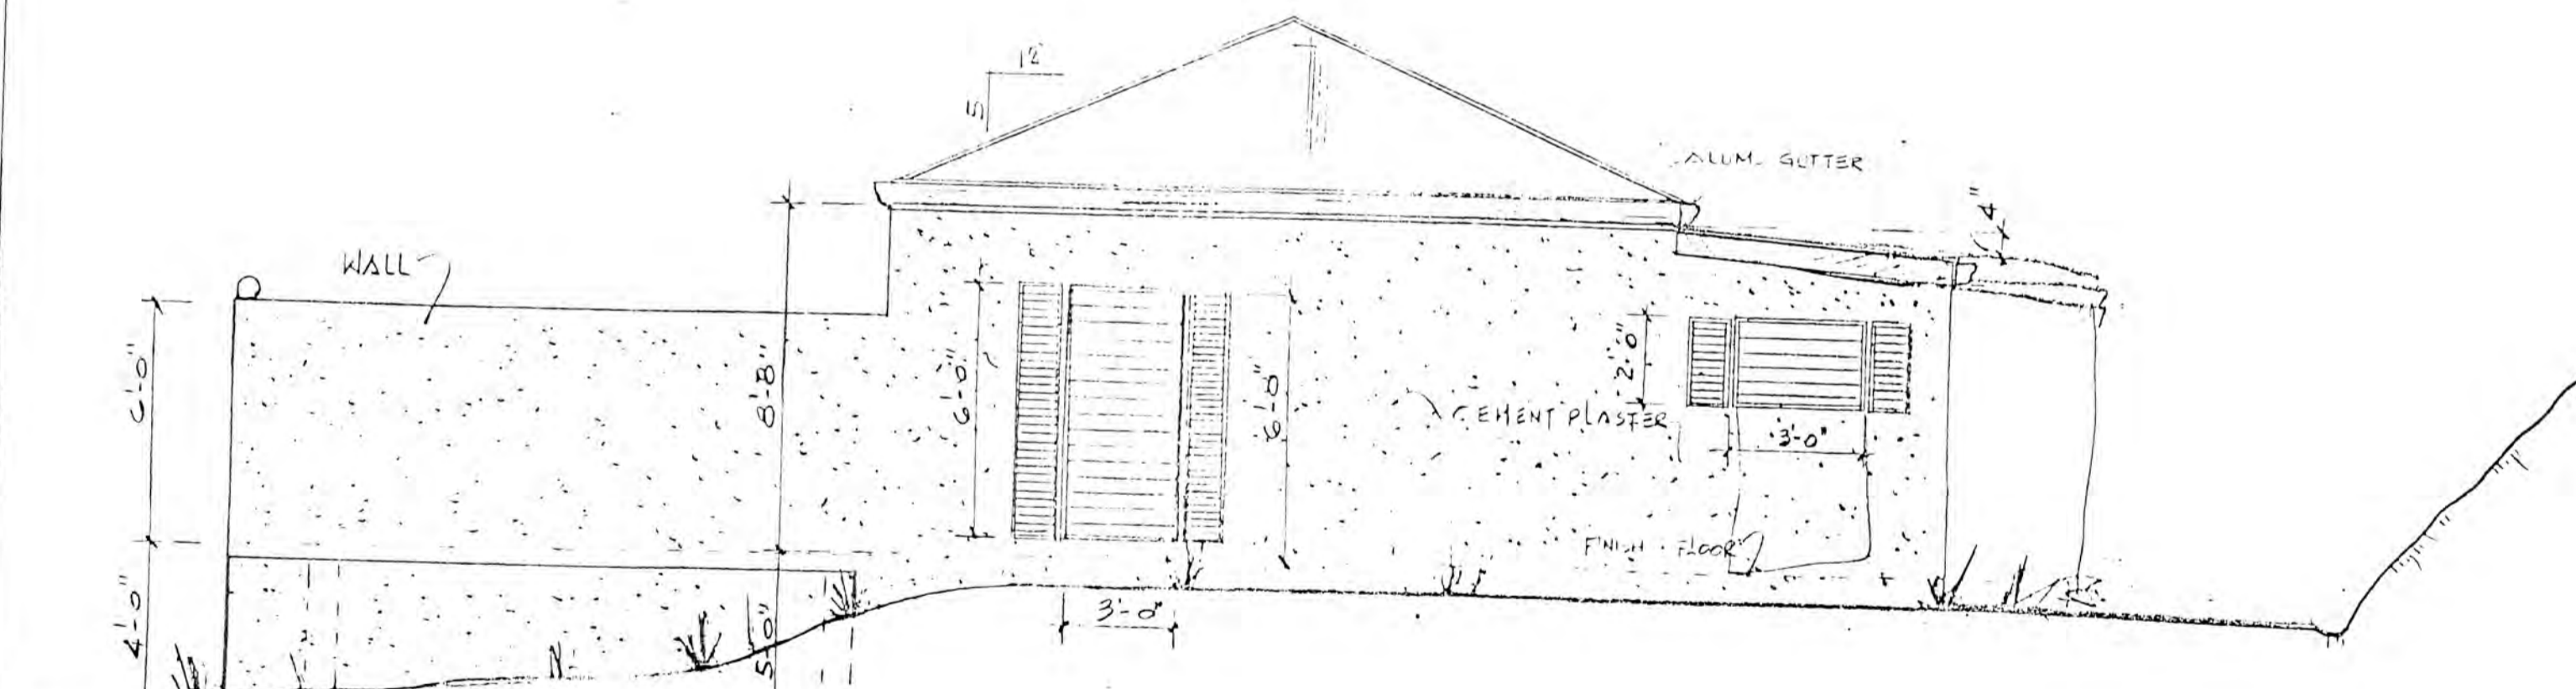

WEST ELEVATION
SC 1/4"=1'-0"






VILLA MADELEINE			
TEAGUE BAY STCROIX			
SOUTH & WEST ELEVATION			
ONE BEDROOM CONDOMINIUM			
DRAWN BY:	DATE	SCALE:	SHEET NO
			7 OF 11

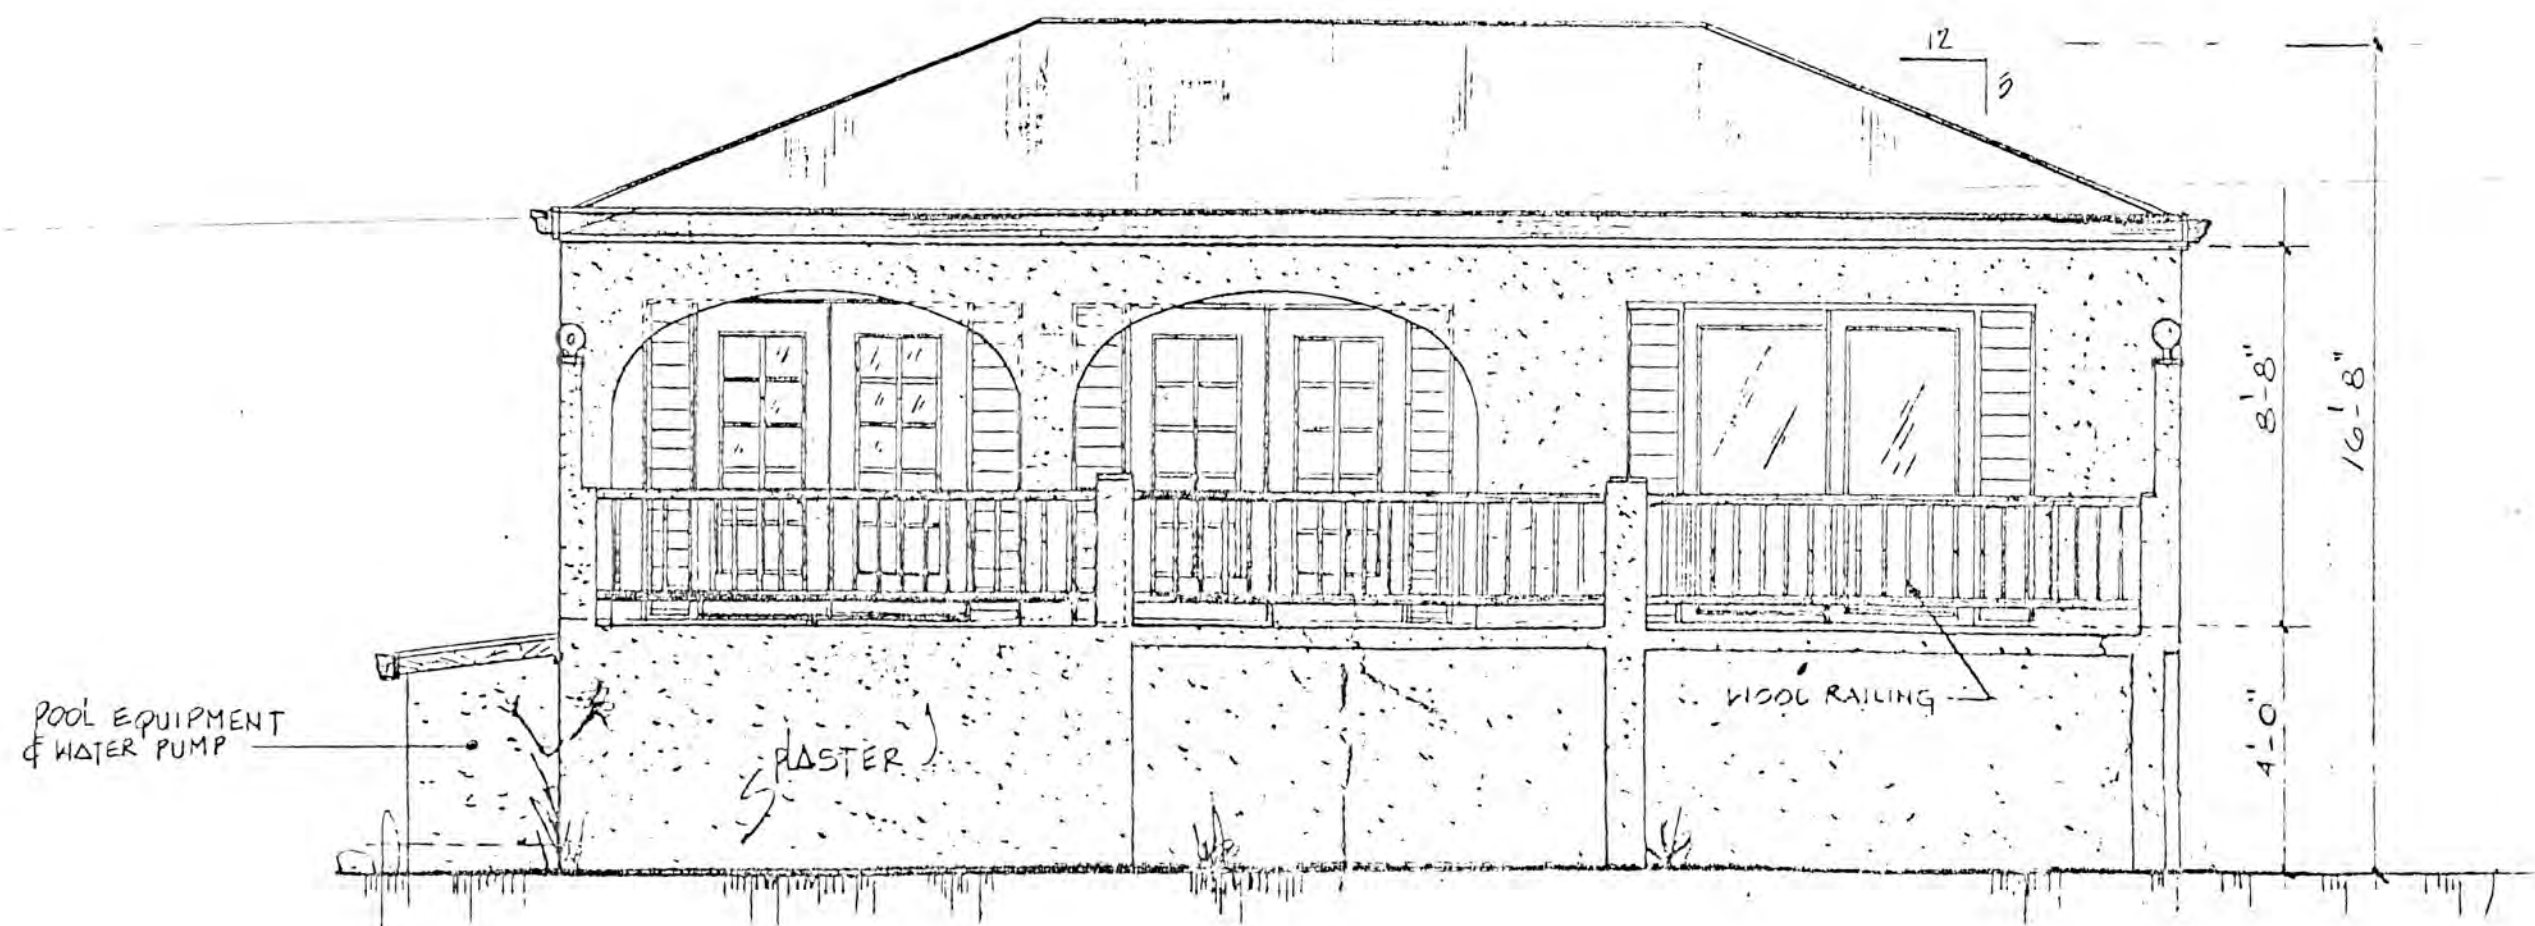

NORTH ELEVATION

1/4" = 1'-0"

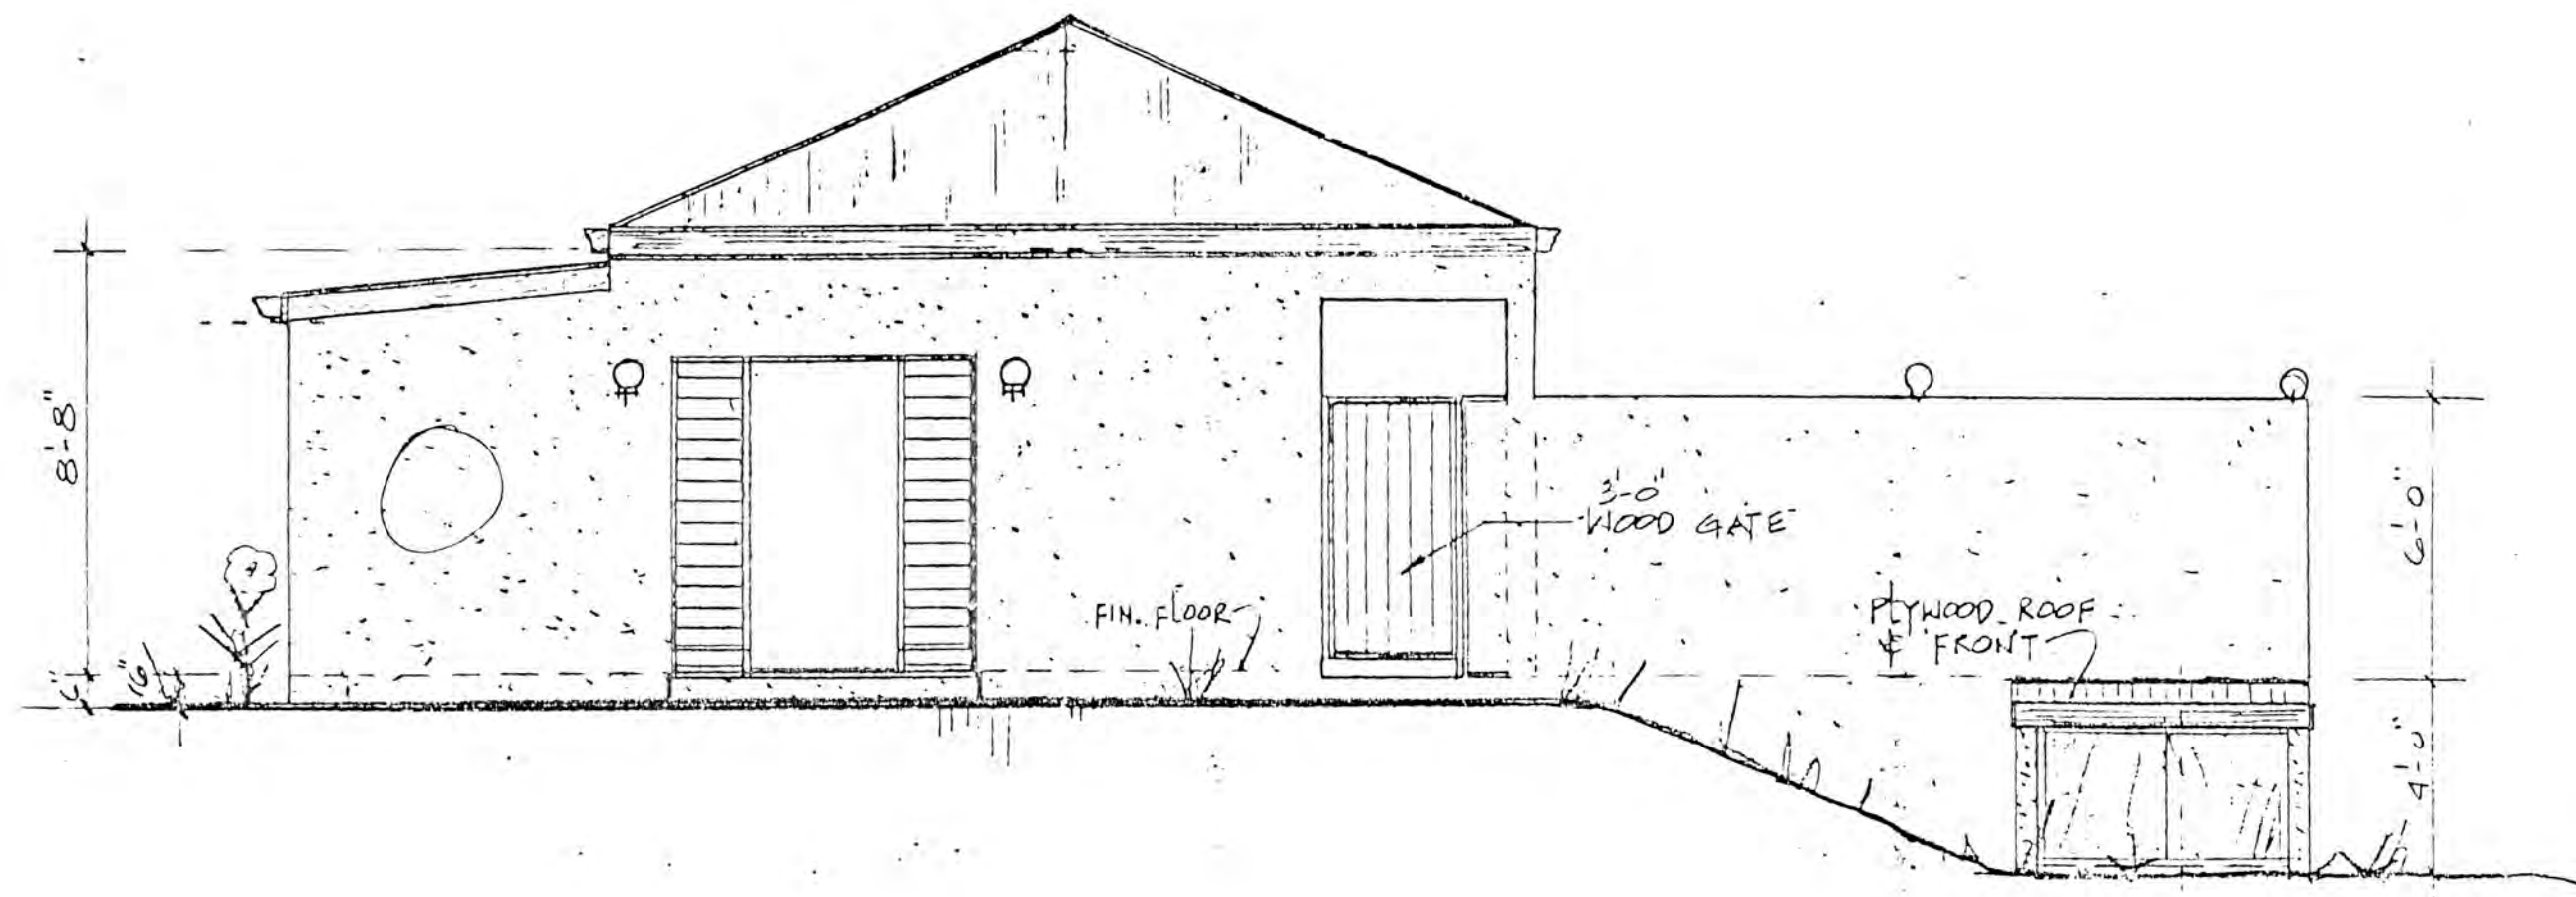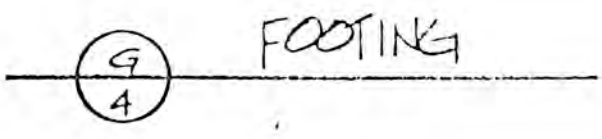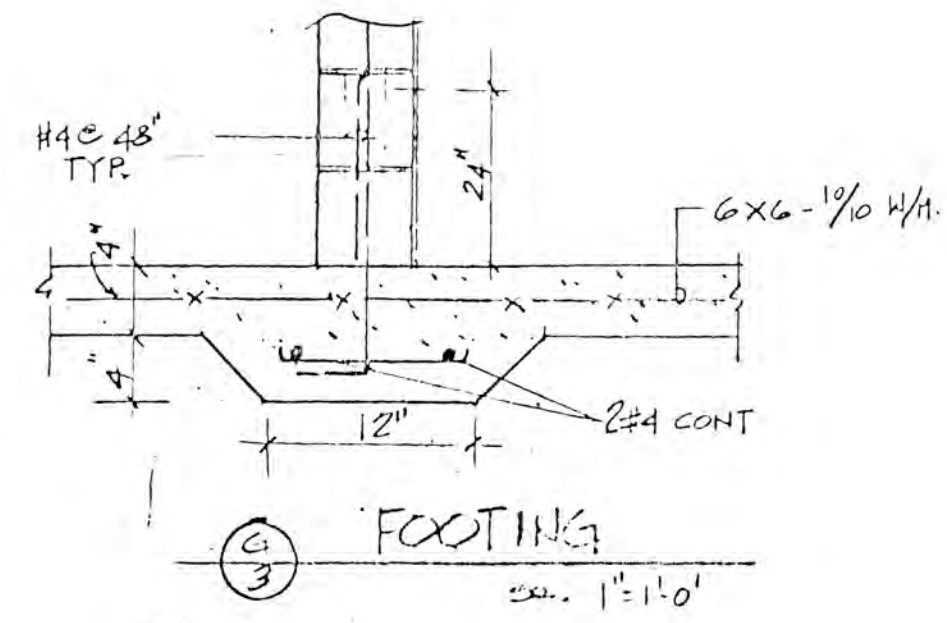


EAST ELEVATION

1/4" = 1'-0"




VILLA MADELEINE			
TEAGUE BAY ST. CROIX			
NORTH & EAST ELEVATION			
ONE BEDROOM CONDOMINIUM			
DRAWN BY:	DATE:	SCALE:	SHEET NO.
CPW.			6 of 11

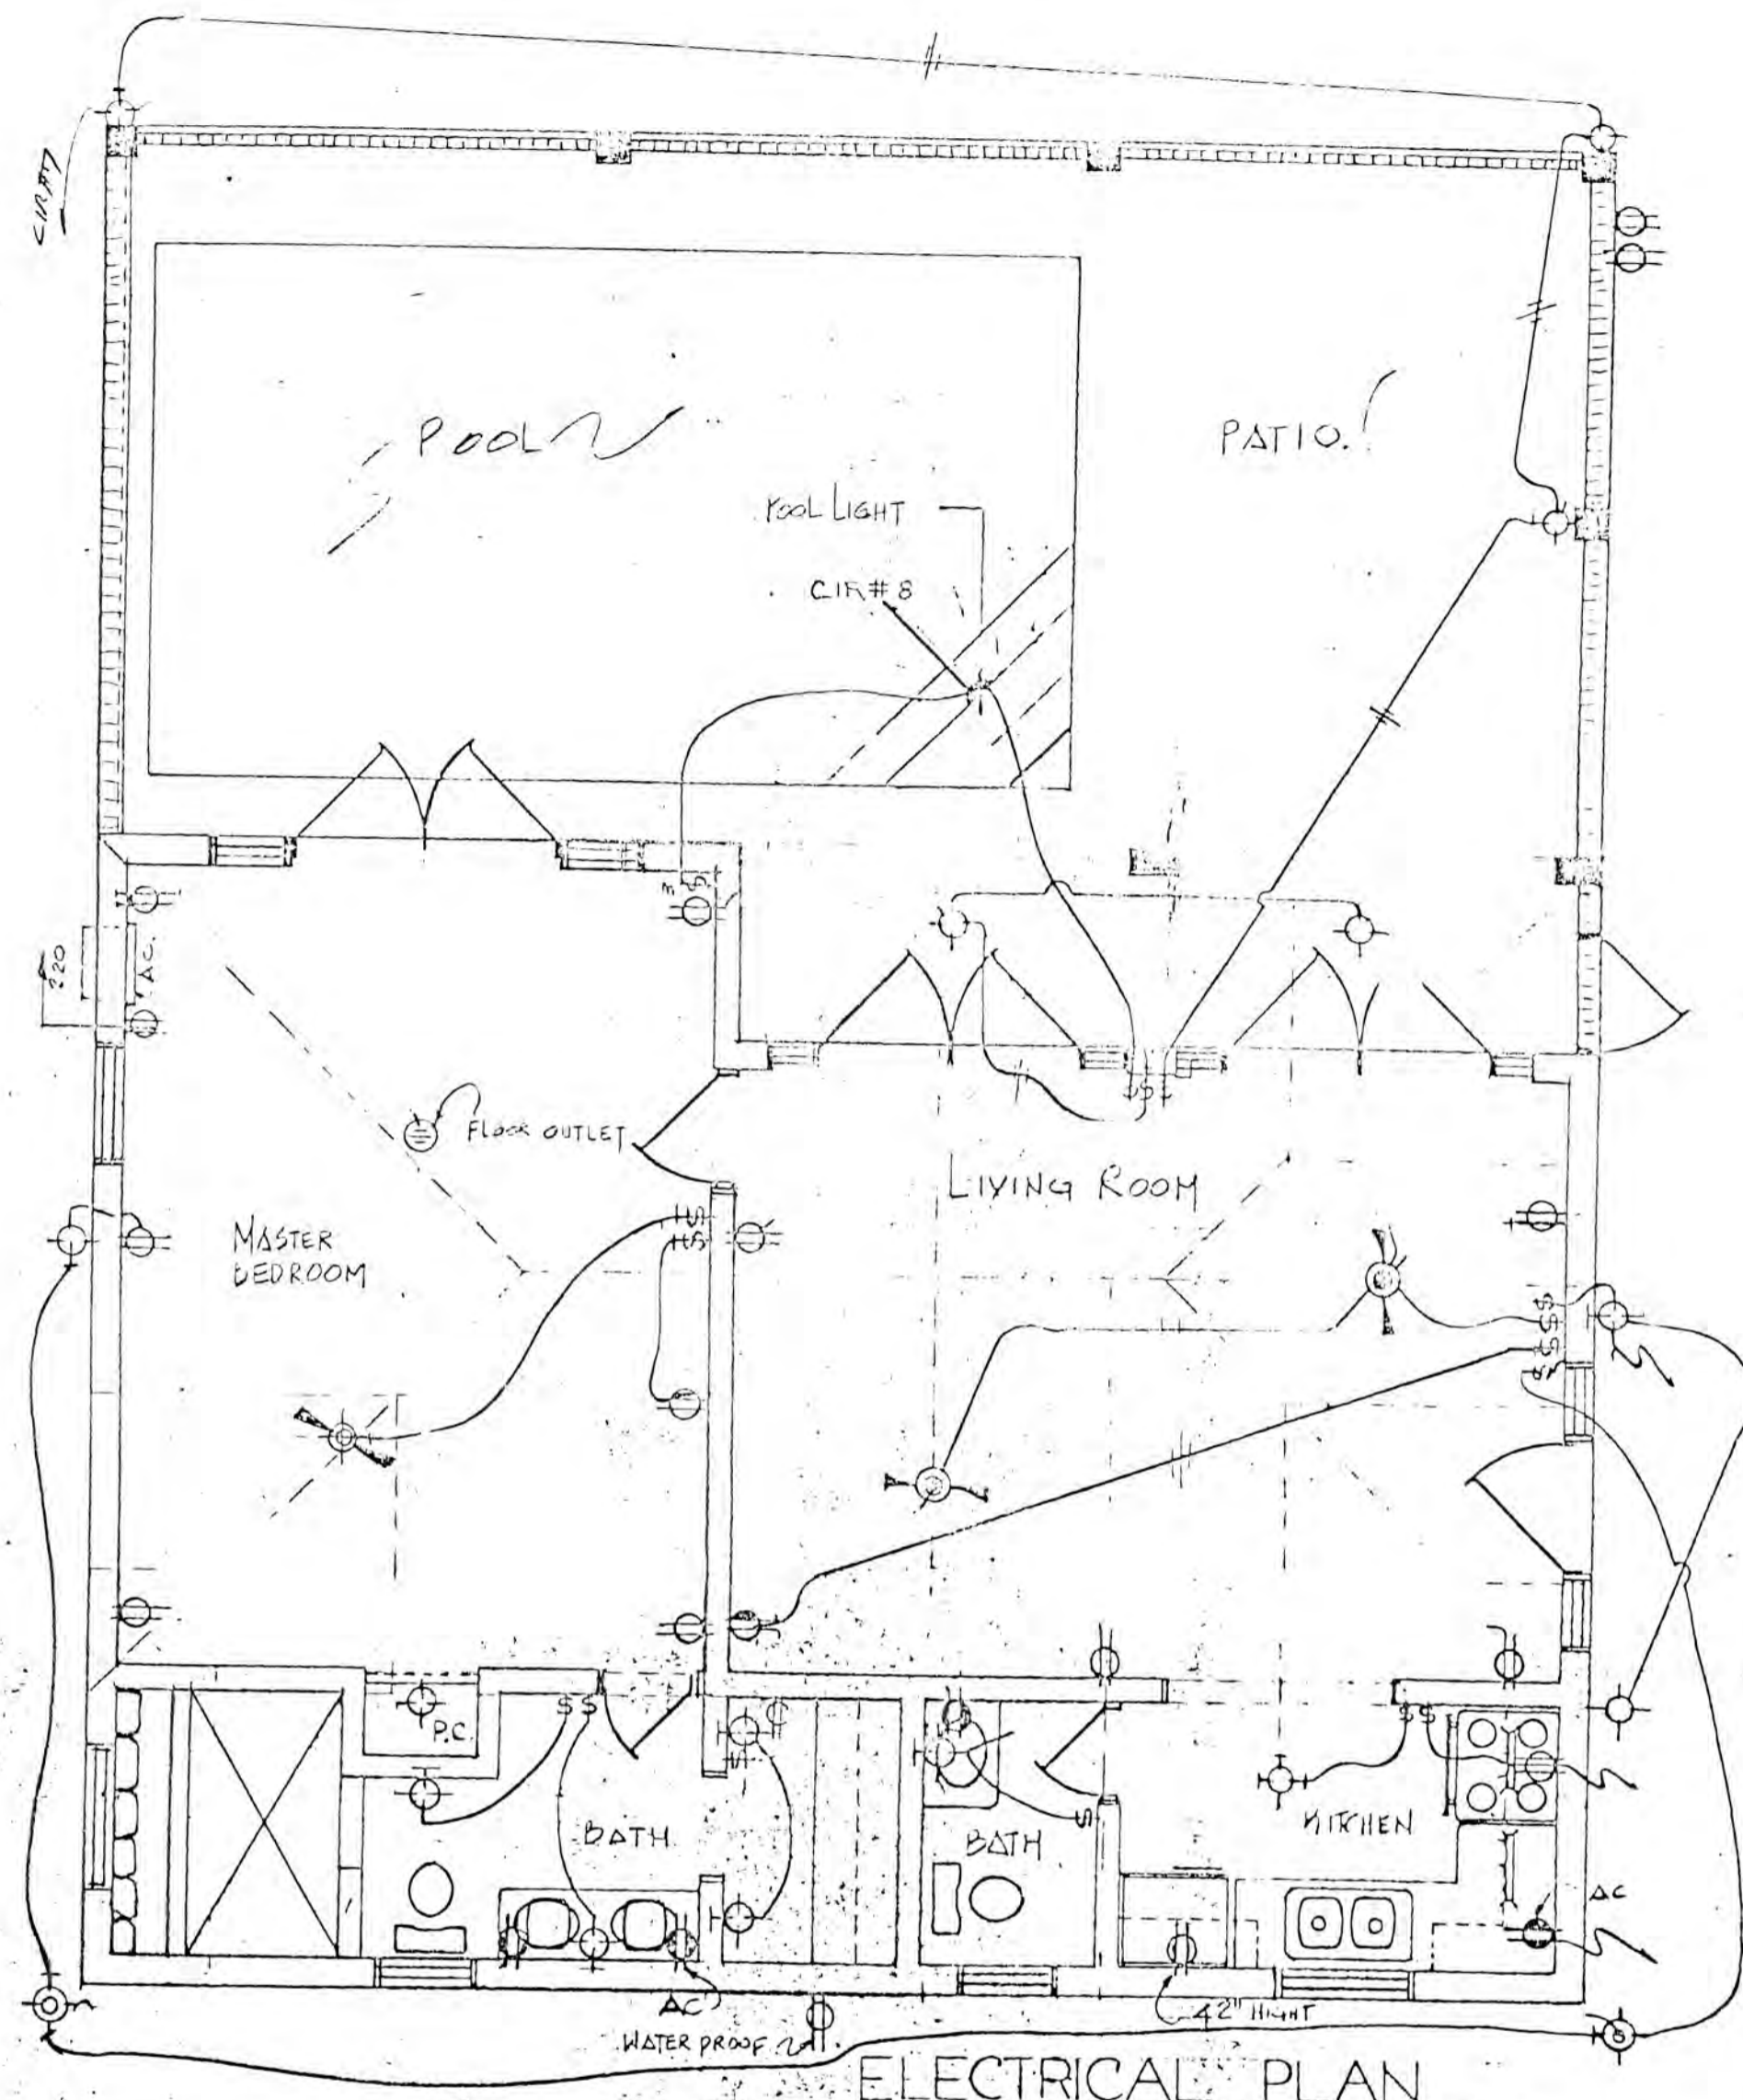


ELECTRICAL PLAN

Sc 1/4" = 1'-0"


SYMBOLS	DESCRIPTIONS
	ELECTRICAL PANEL BOX
	DUPLEX RECEPTACLE 12' F.F.F.
	DUPLEX RECEPTACLE ABOVE CABINET
	220 VOLTS RECEPTACLE
	WALL MOUNTED CEILING LAMP
	LIGHT SWITCH - SINGLE POLE
	METER BASE
	CEILING FAN 52" ϕ
	SWITCHED OUTLET
	FLUORESCENT LIGHT

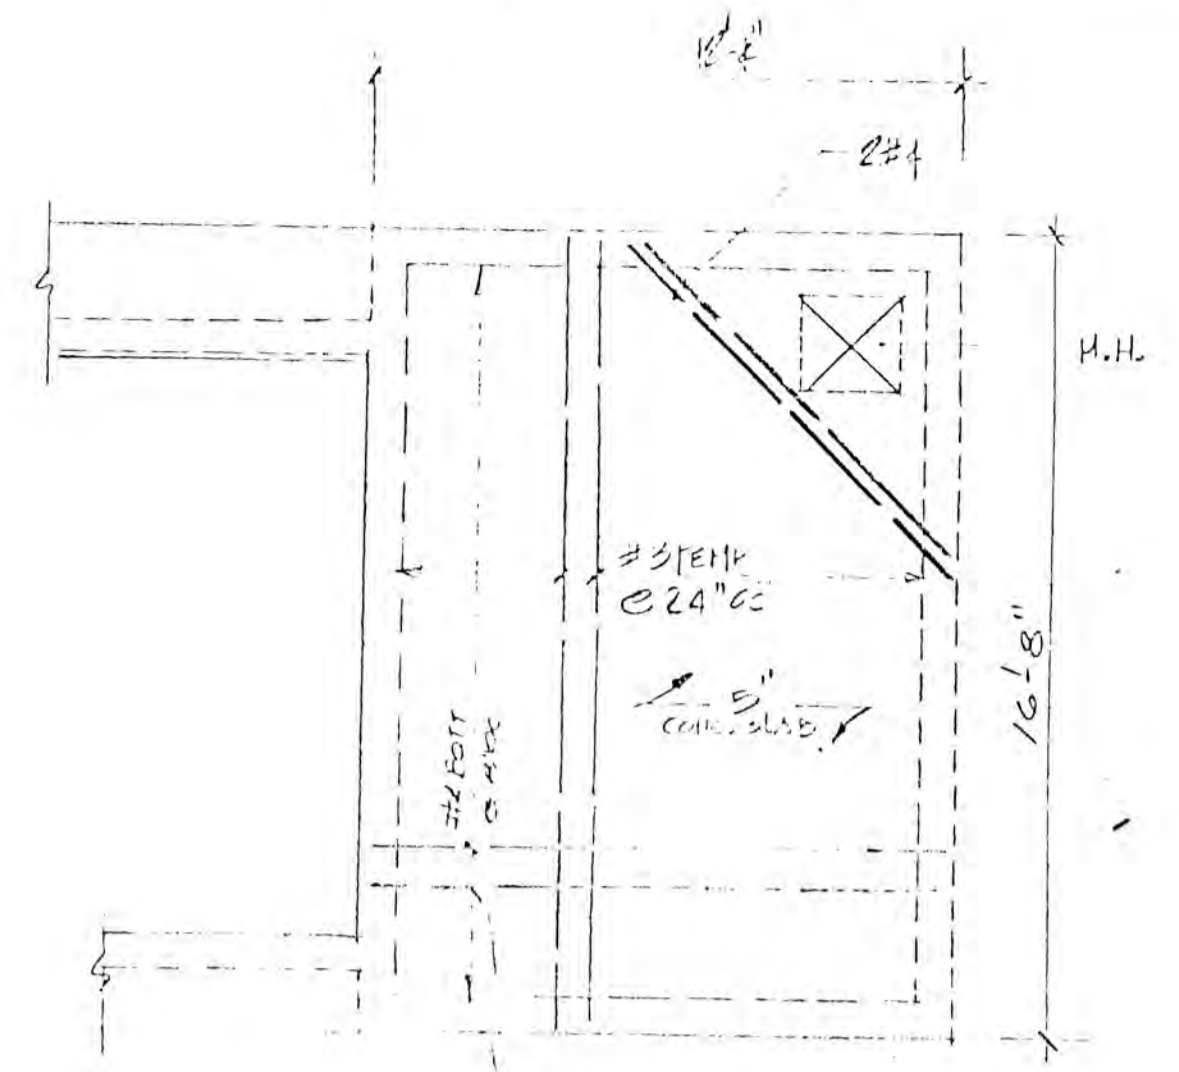


CISTERN STRUCTURAL

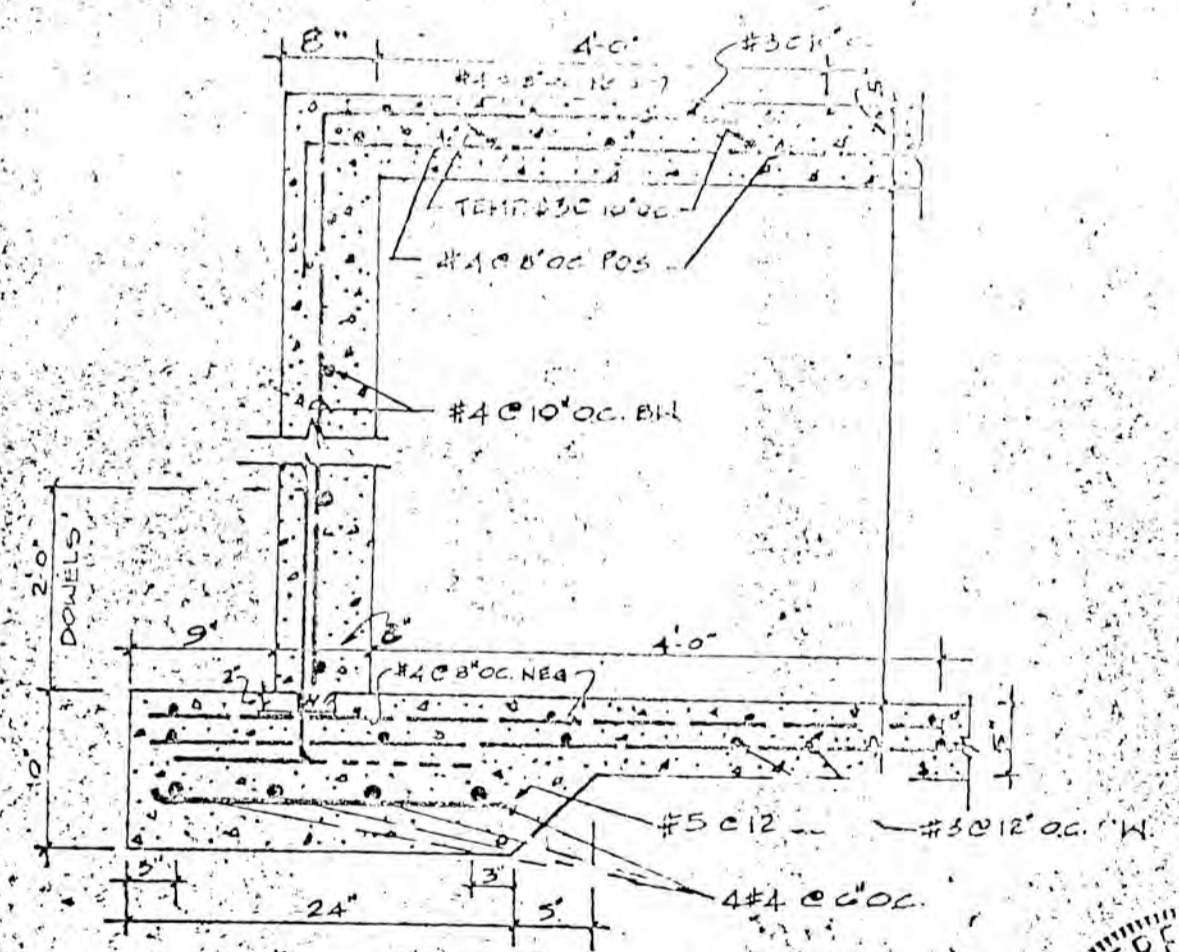



CISTERN DETAIL F-2

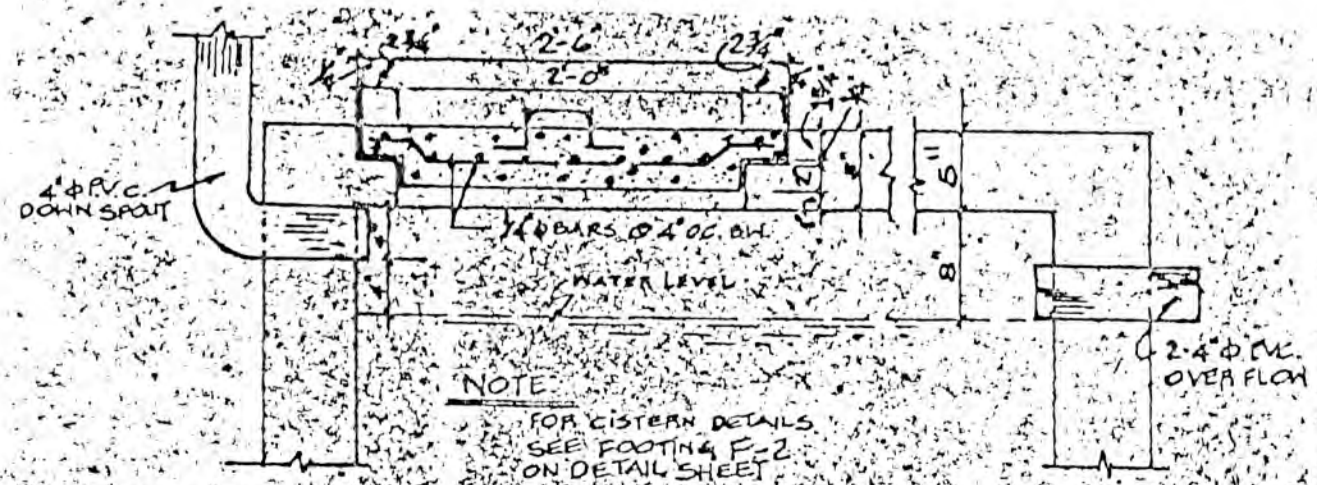


CISTERN MANHOLE DETAIL

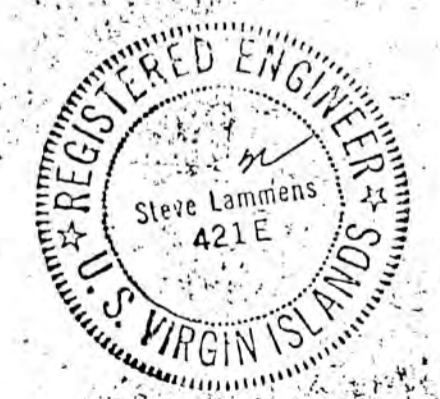


VILLA MADELEINE			
TEAGUE BAY		ST. CROIX	
ONE - BEDROOM CONDOMINIUM			
DRAWN BY: V. SCHNEIDER	DATE:	SCALE: 1/4" = 1'-0"	SHEET NO: 18 OF 11

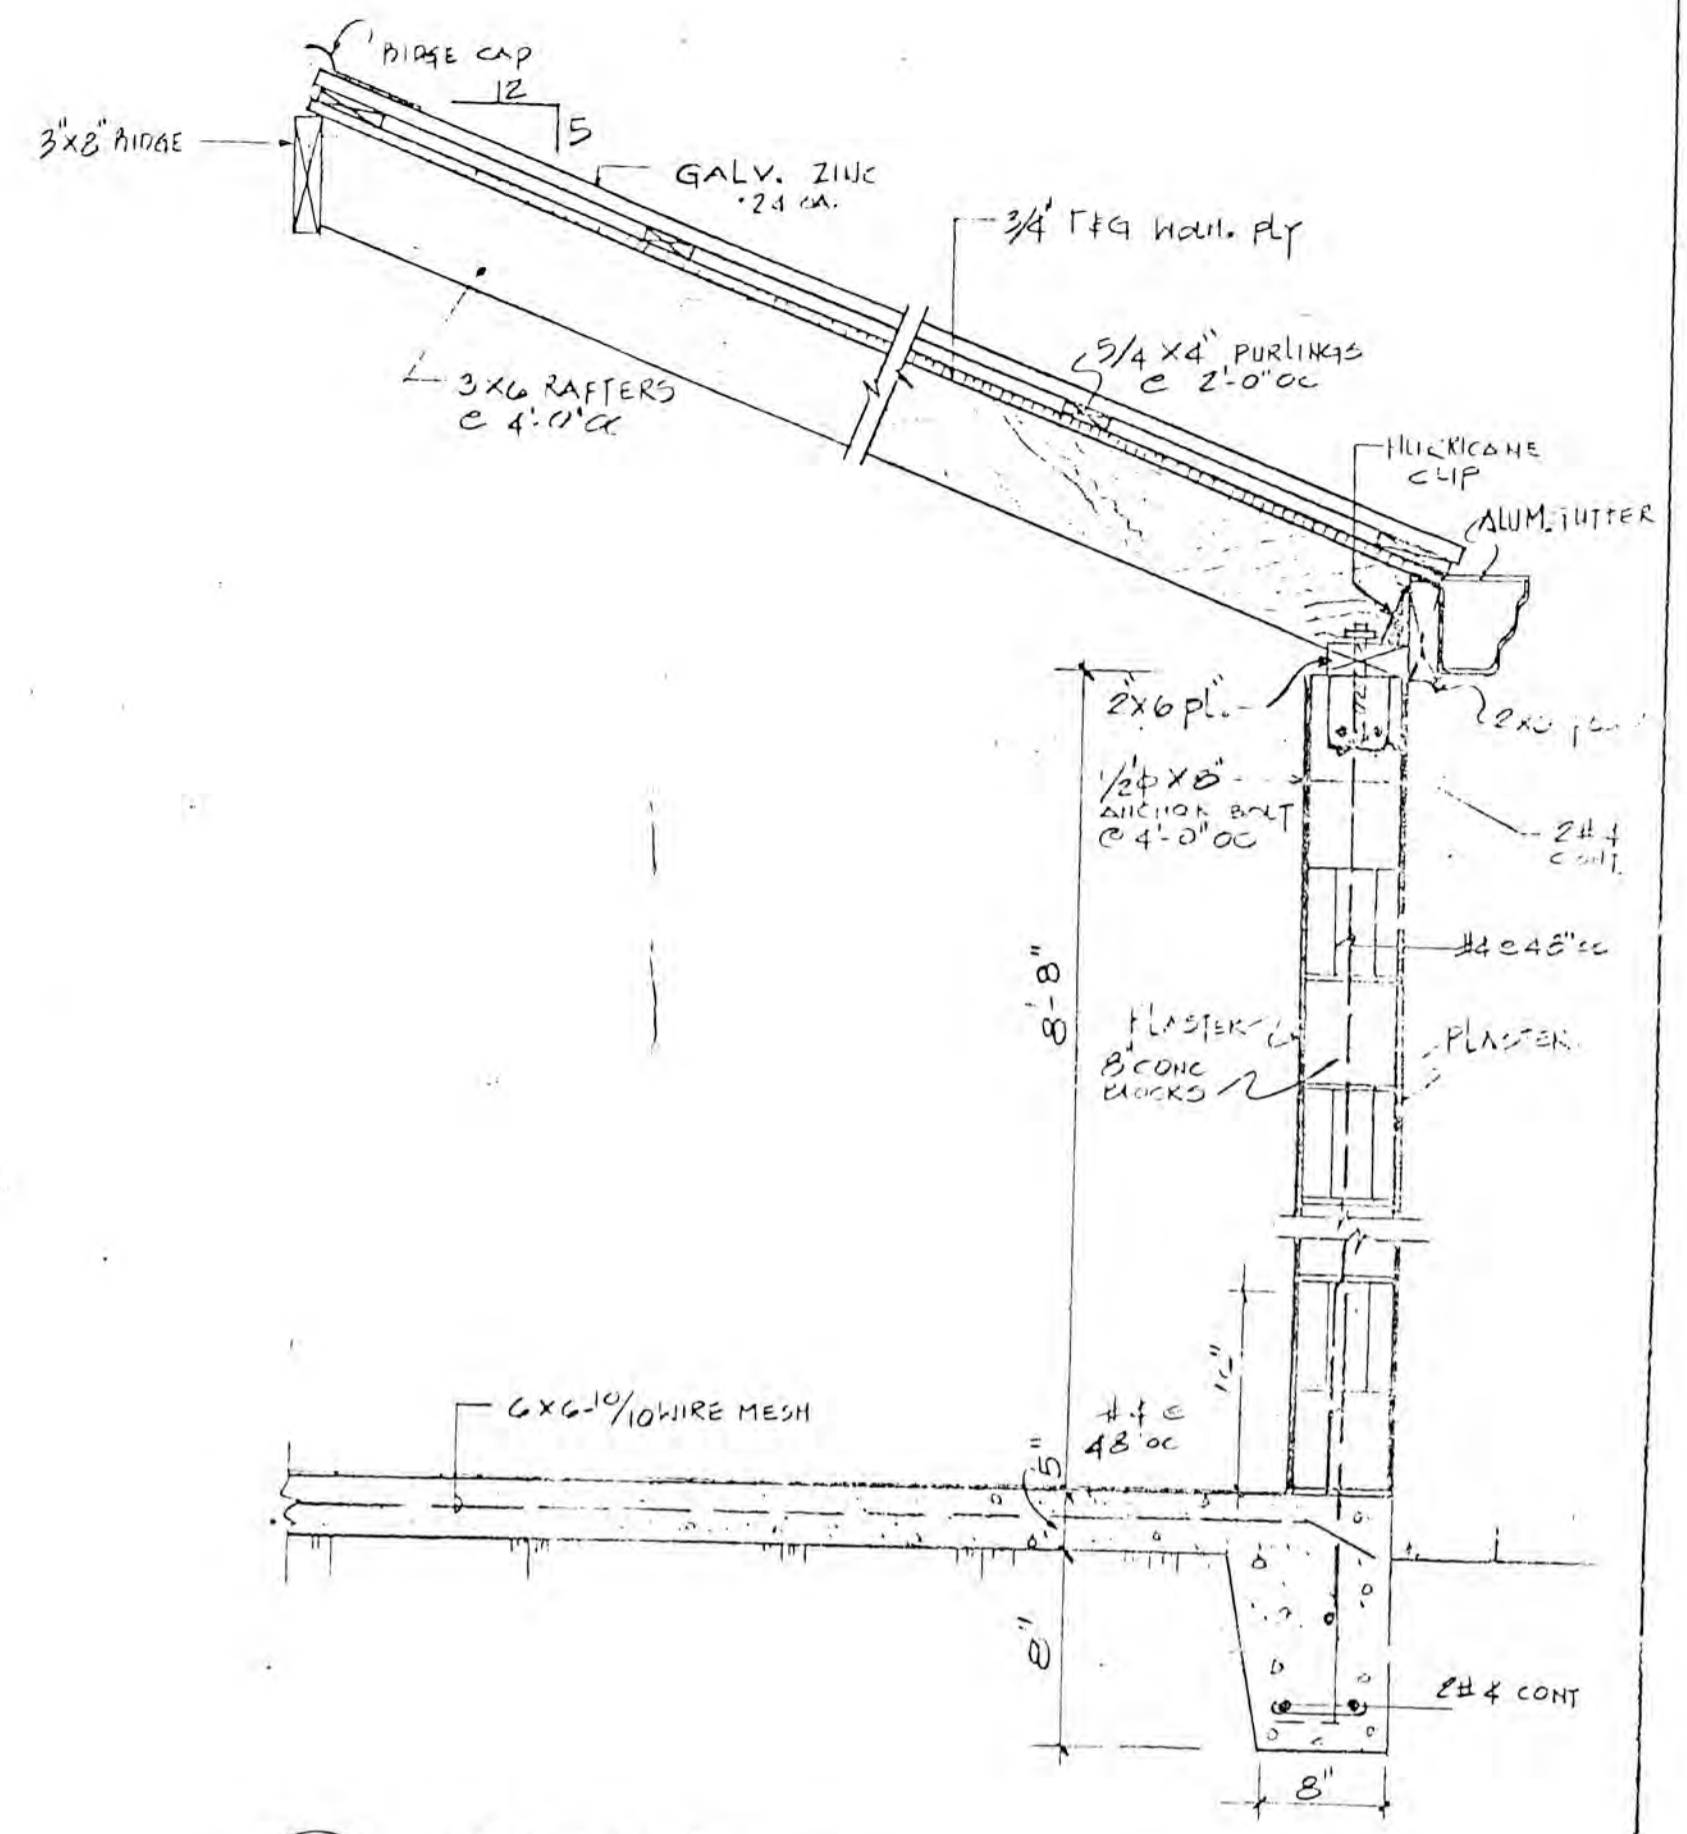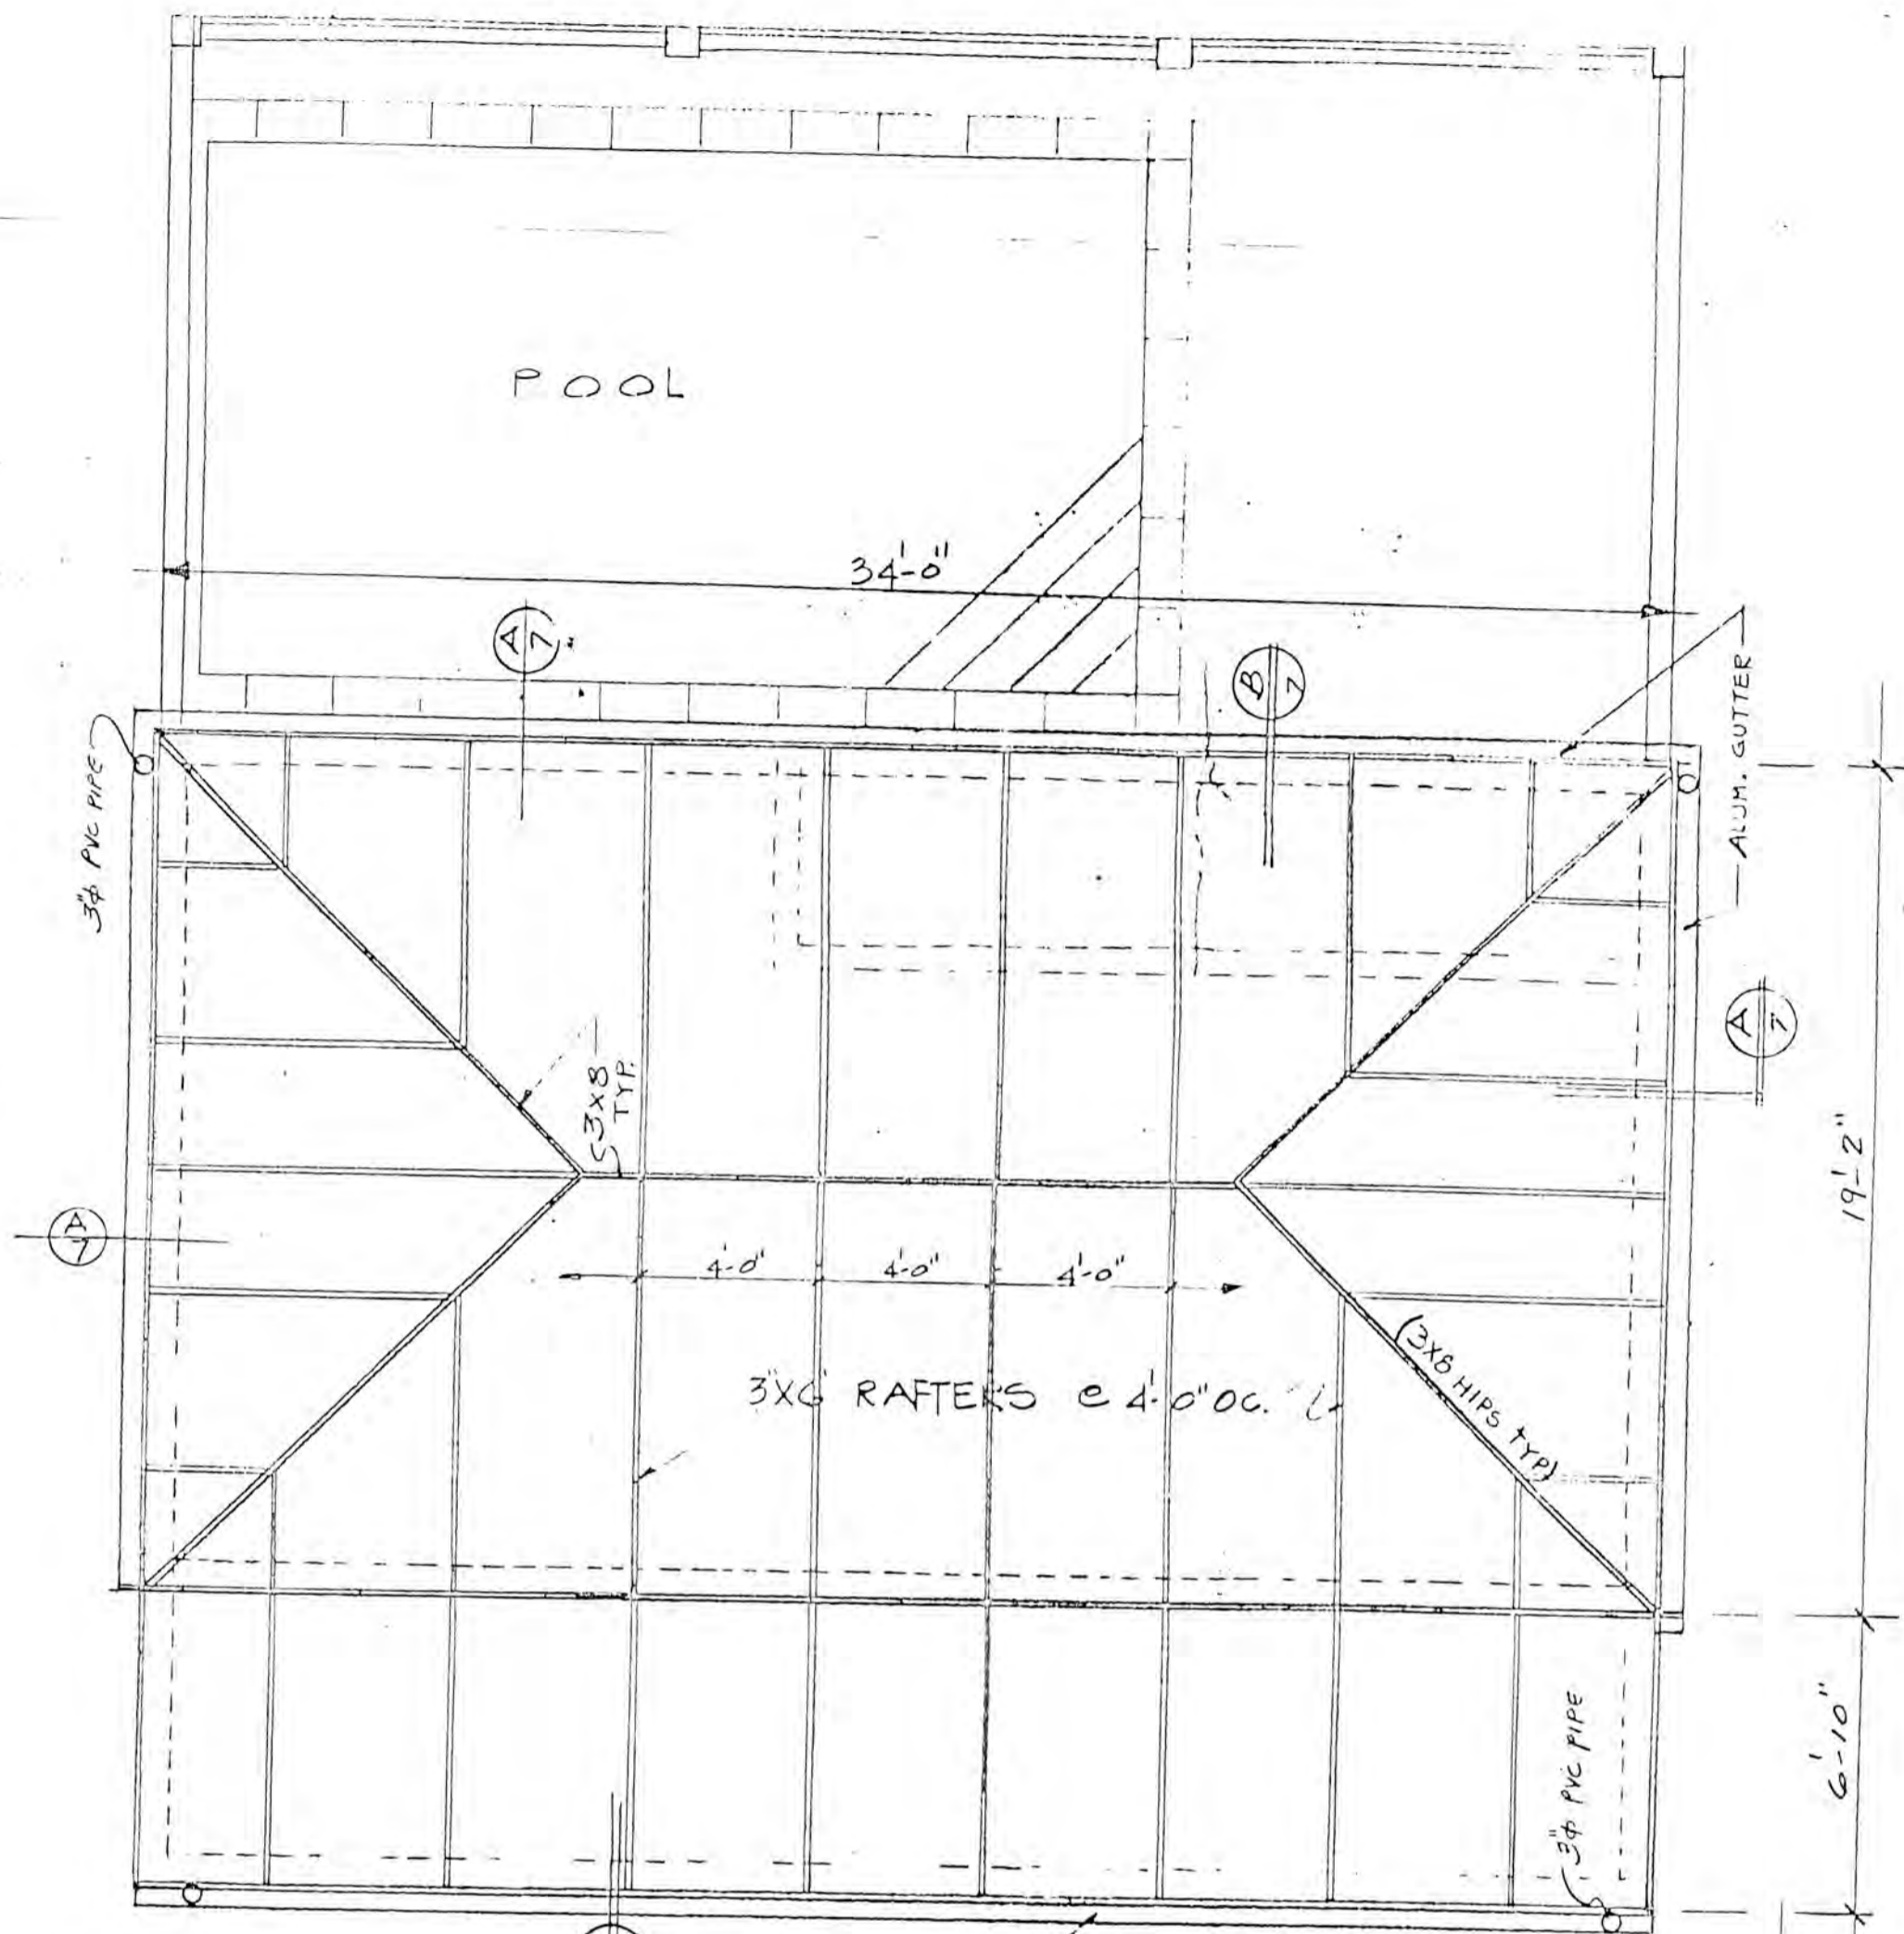

A SECTION
 1" = 1'-0"

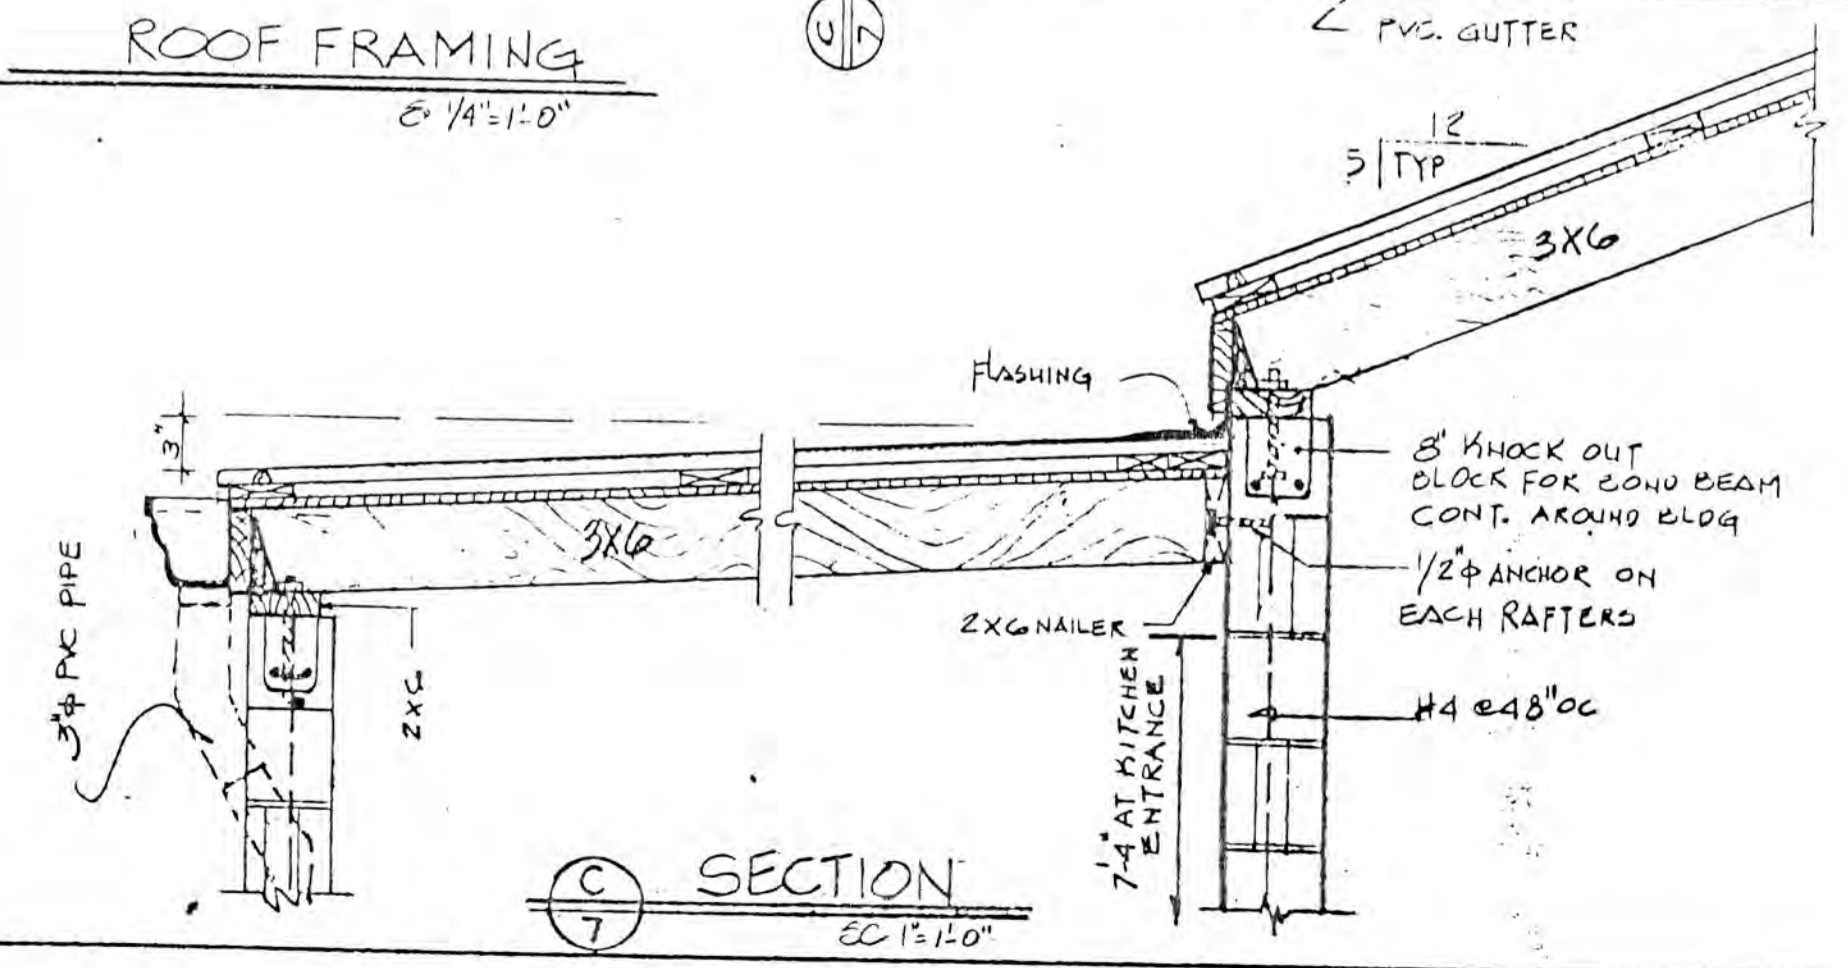


C SECTION
 1" = 1'-0"

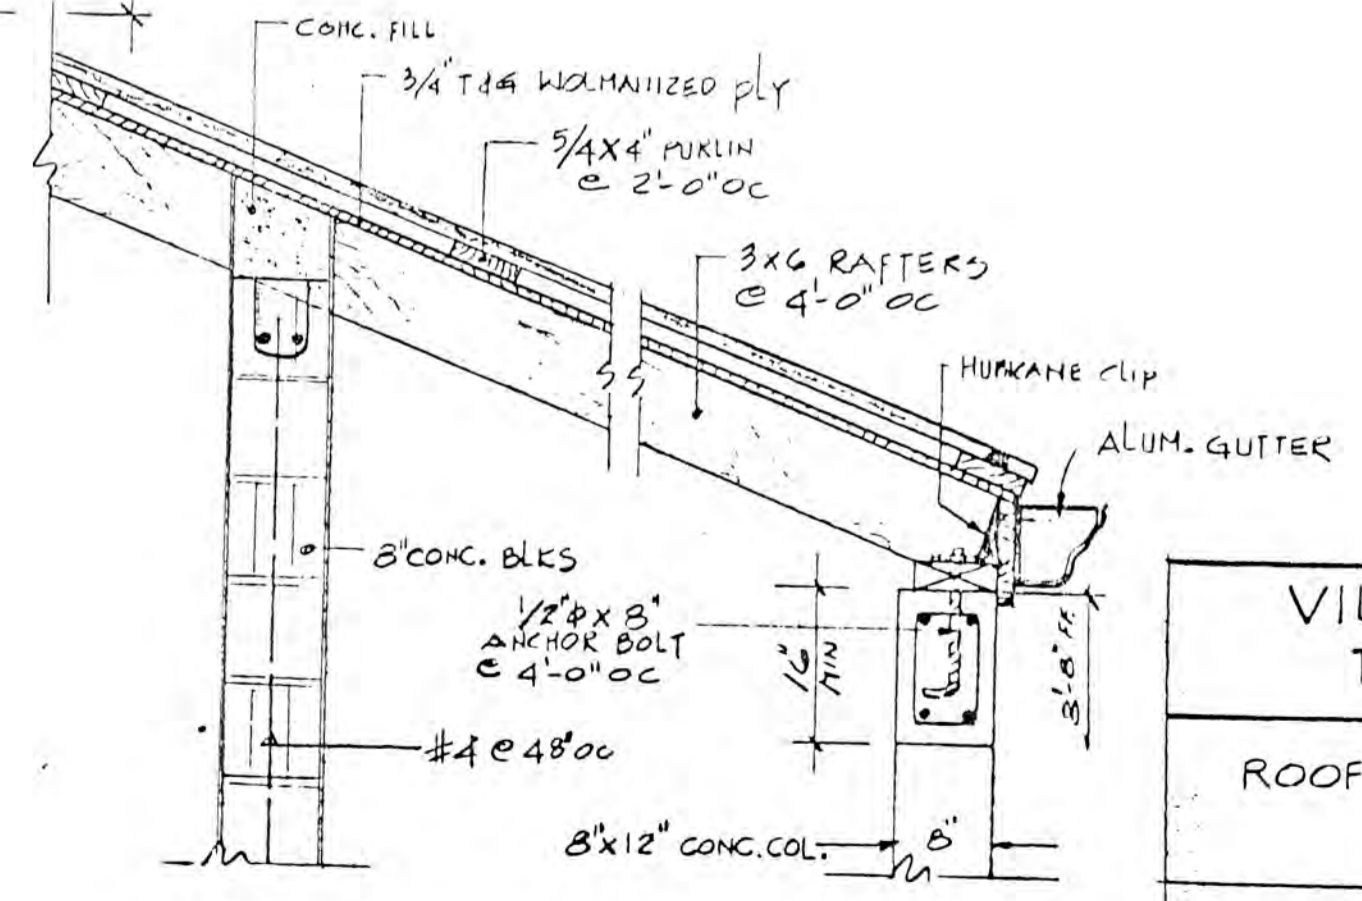


B SECTION
 1" = 1'-0"




VILLA MADELEINE			
TEAGUE BAY ST. CROIX			
ROOF FRAMING AND SECTIONS			
ONE BEDROOM CONDOMINIUM			
DRAWN BY: C. R. ...	DATE	SCALE:	SHEET NO. 9 of 11

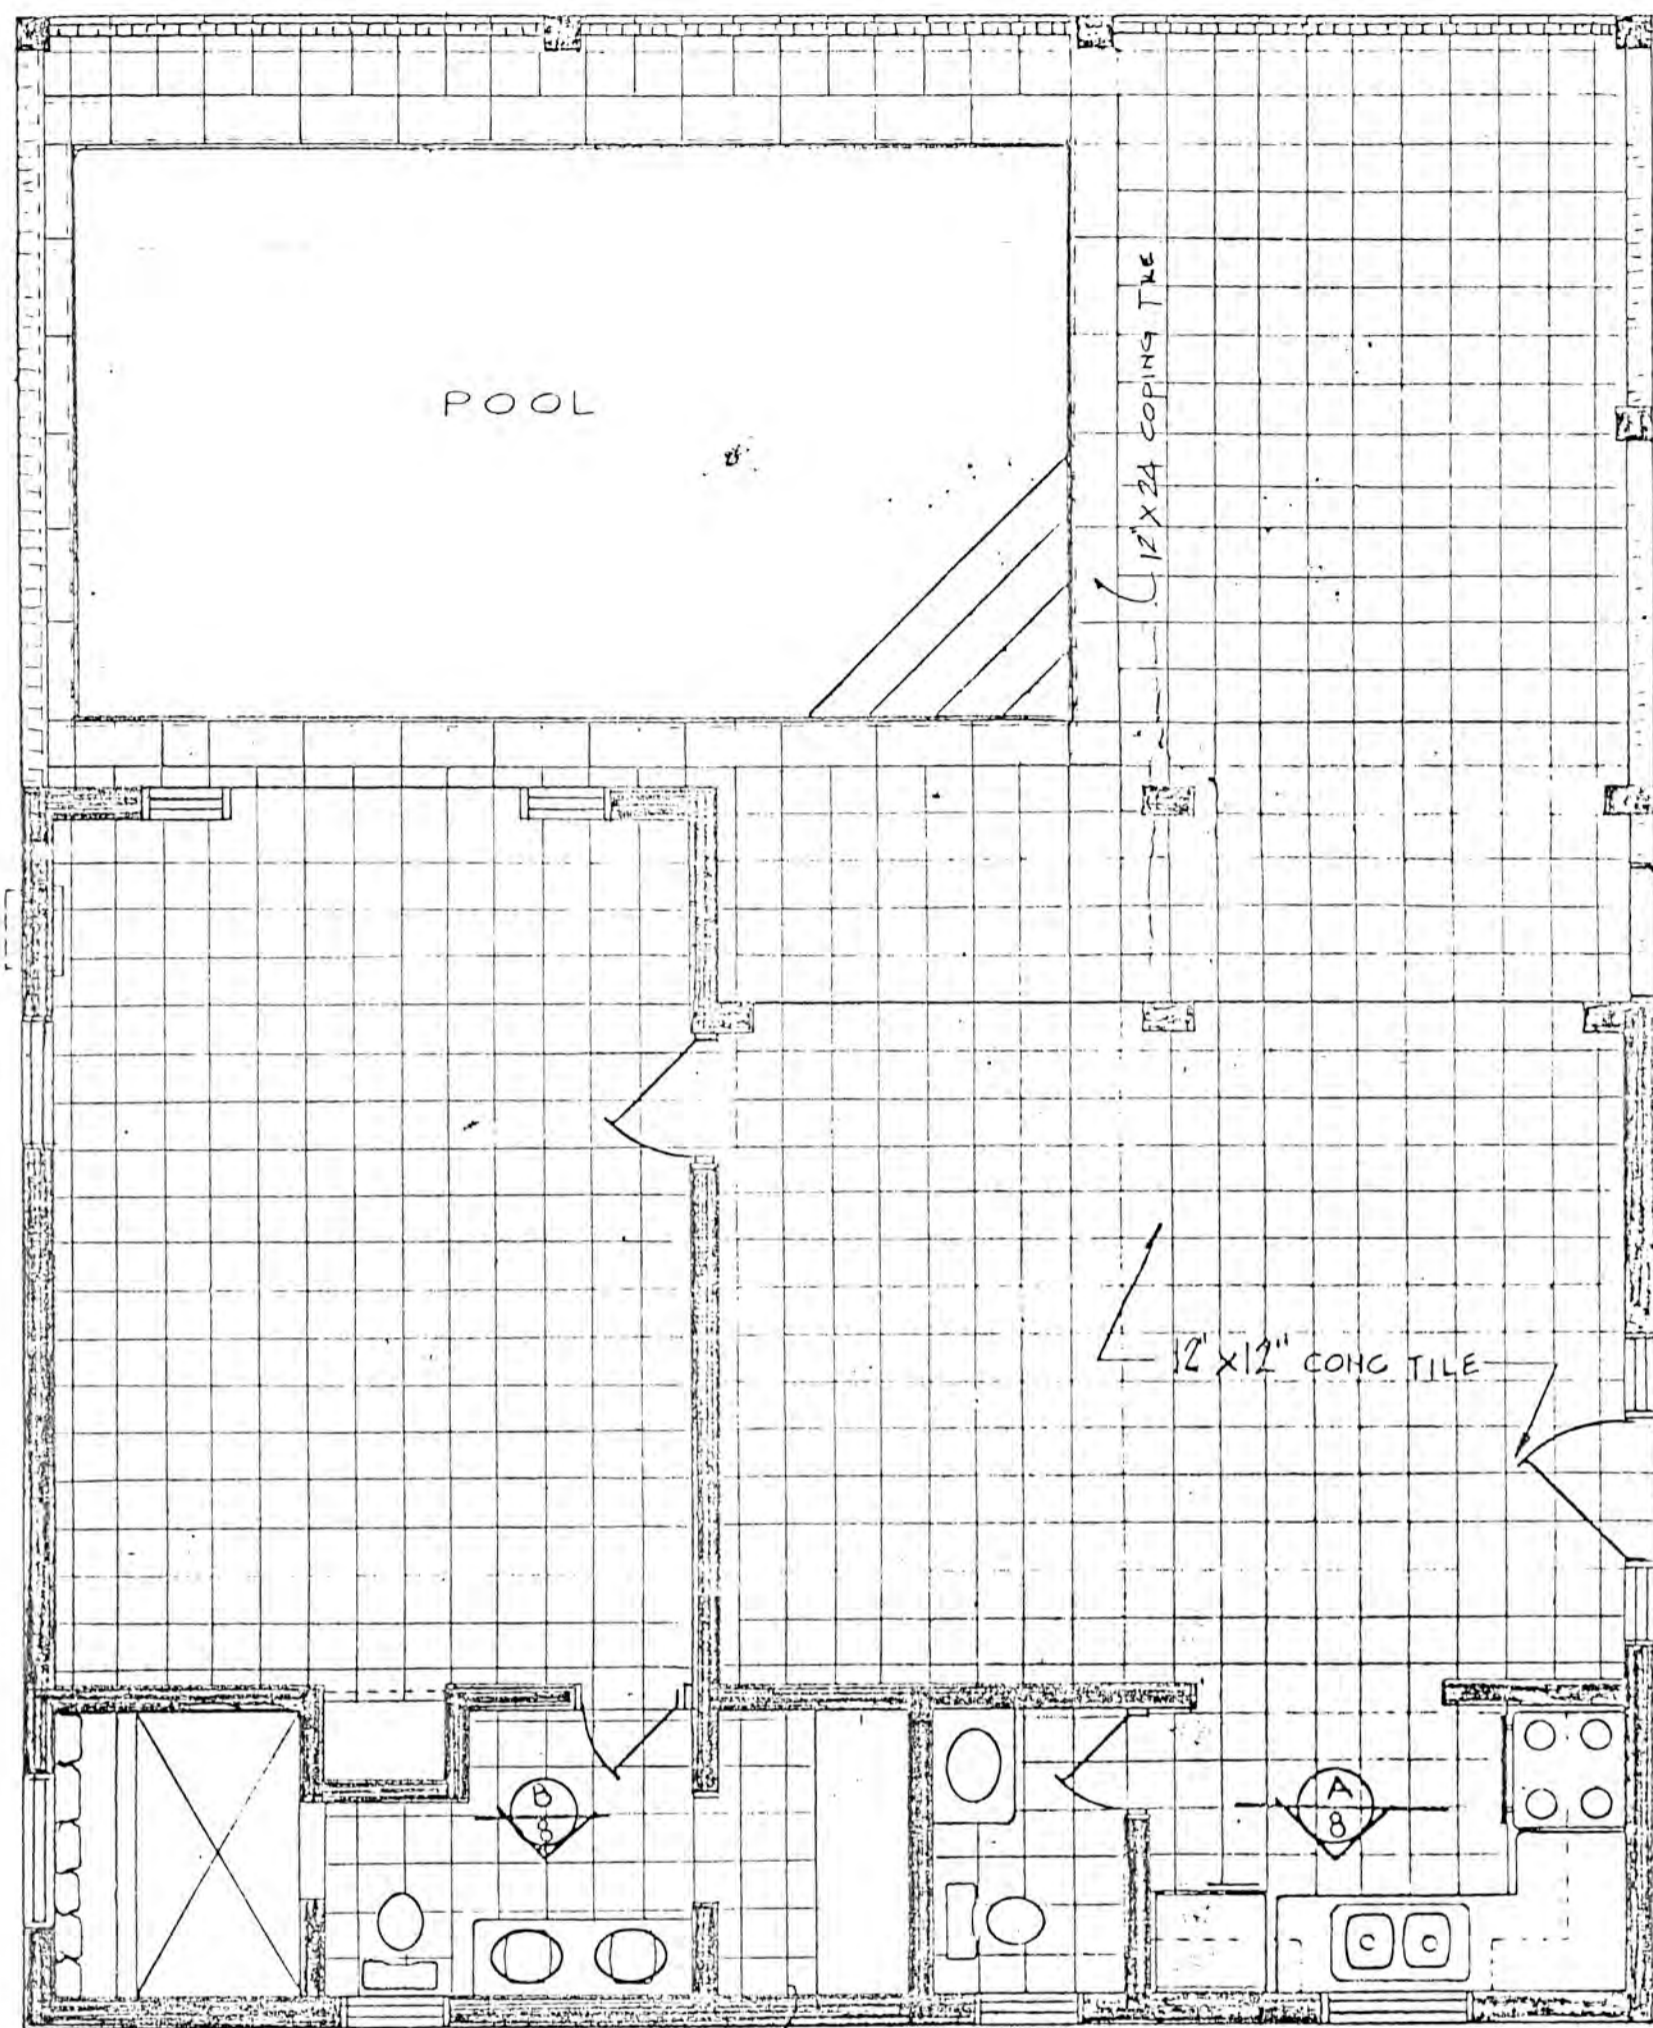

FLOOR TILE LAYOUT
 20' 1/4" = 1'-0"

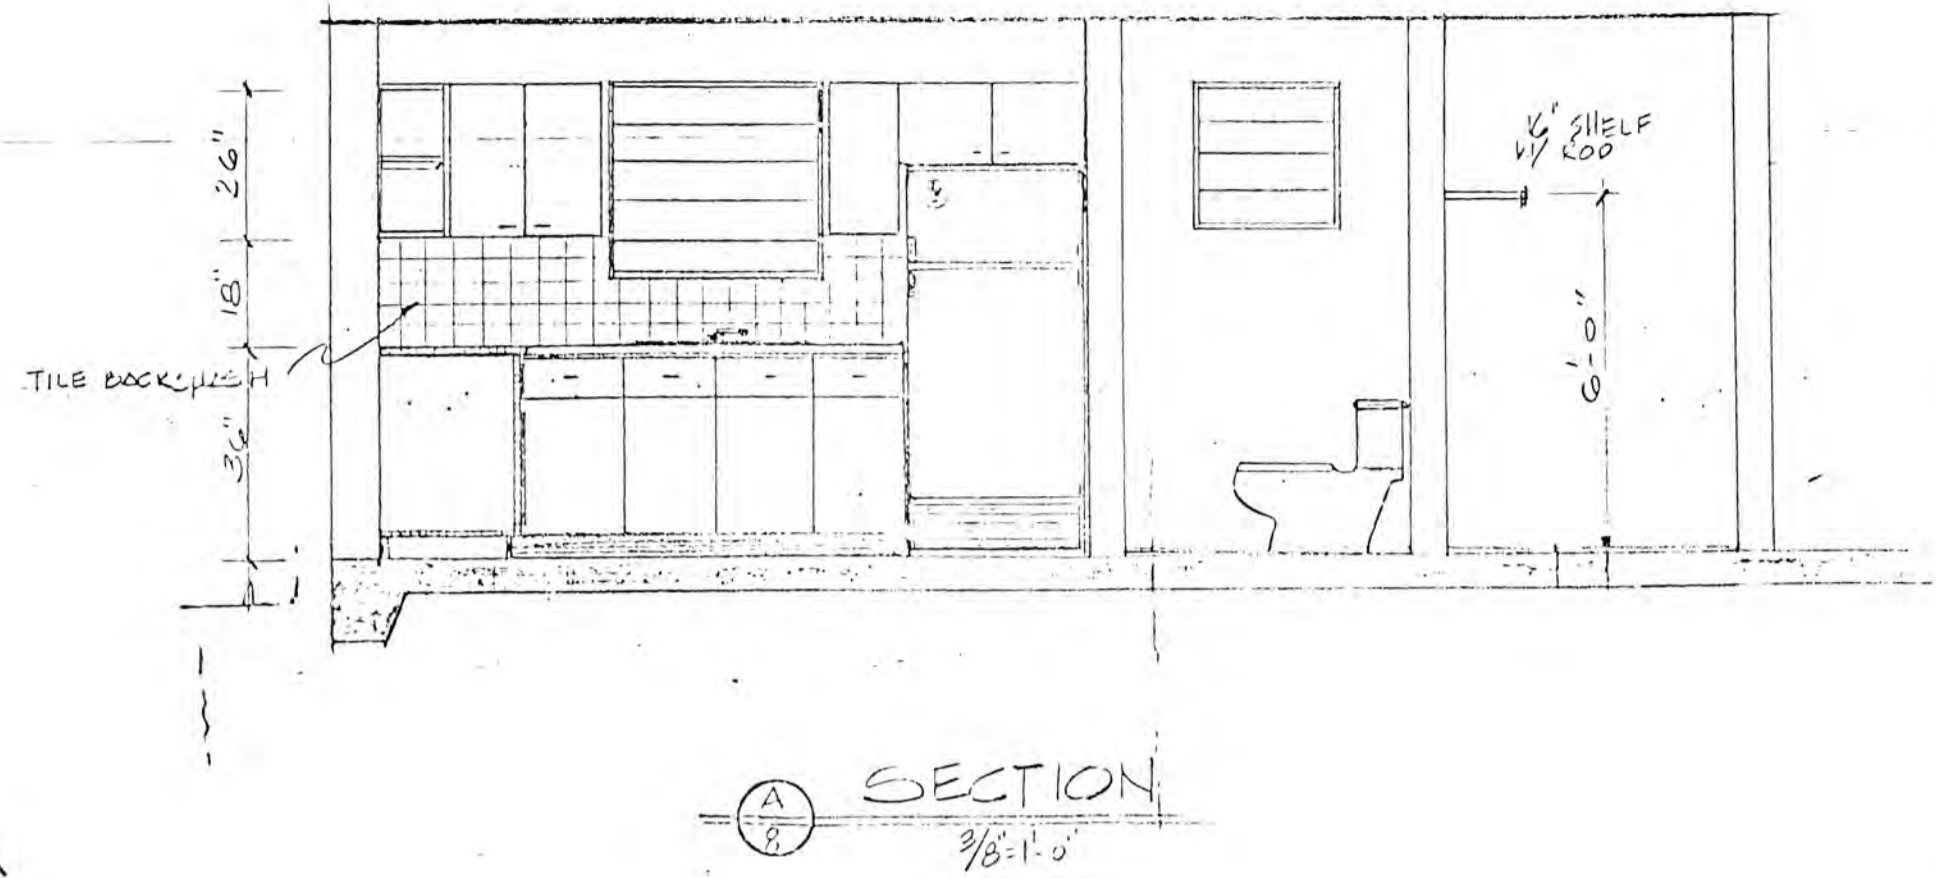


SECTION A
 3/8" = 1'-0"

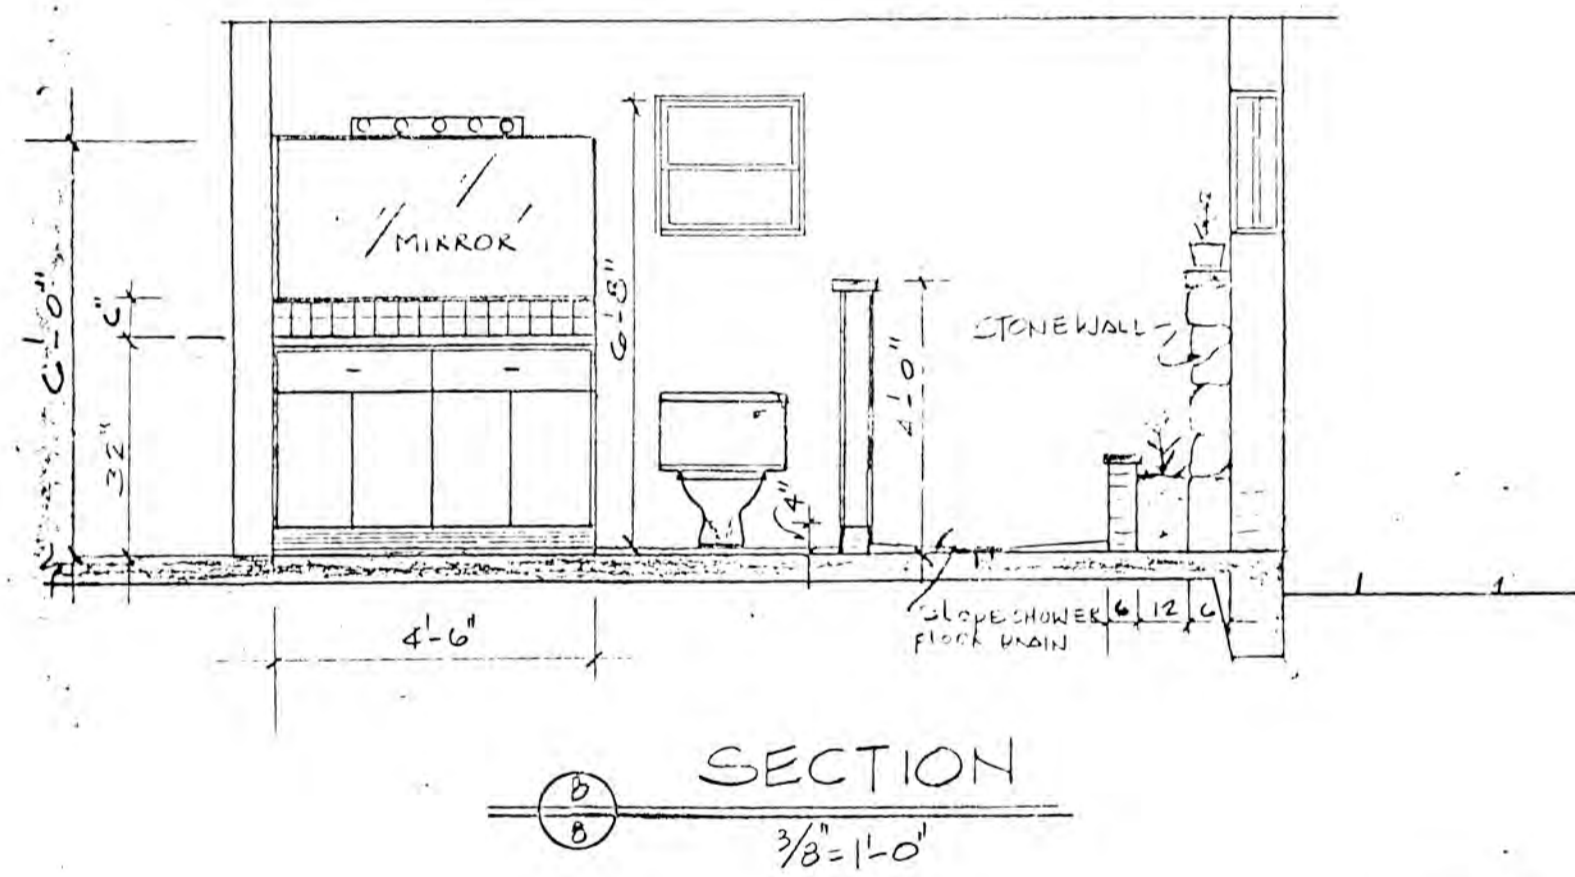

SECTION B
 3/8" = 1'-0"




VILLA MADELEINE			
TEAGUE BAY ST CROIX			
KITCHEN & BATHROOM SECTIONS			
FLOOR TILE LAYOUT			
ONE BEDROOM CONDOMINIUM			
DRAWN BY C RMB	DATE:	SCALE: AS SHOWN	SHEET NO 10 OF 11

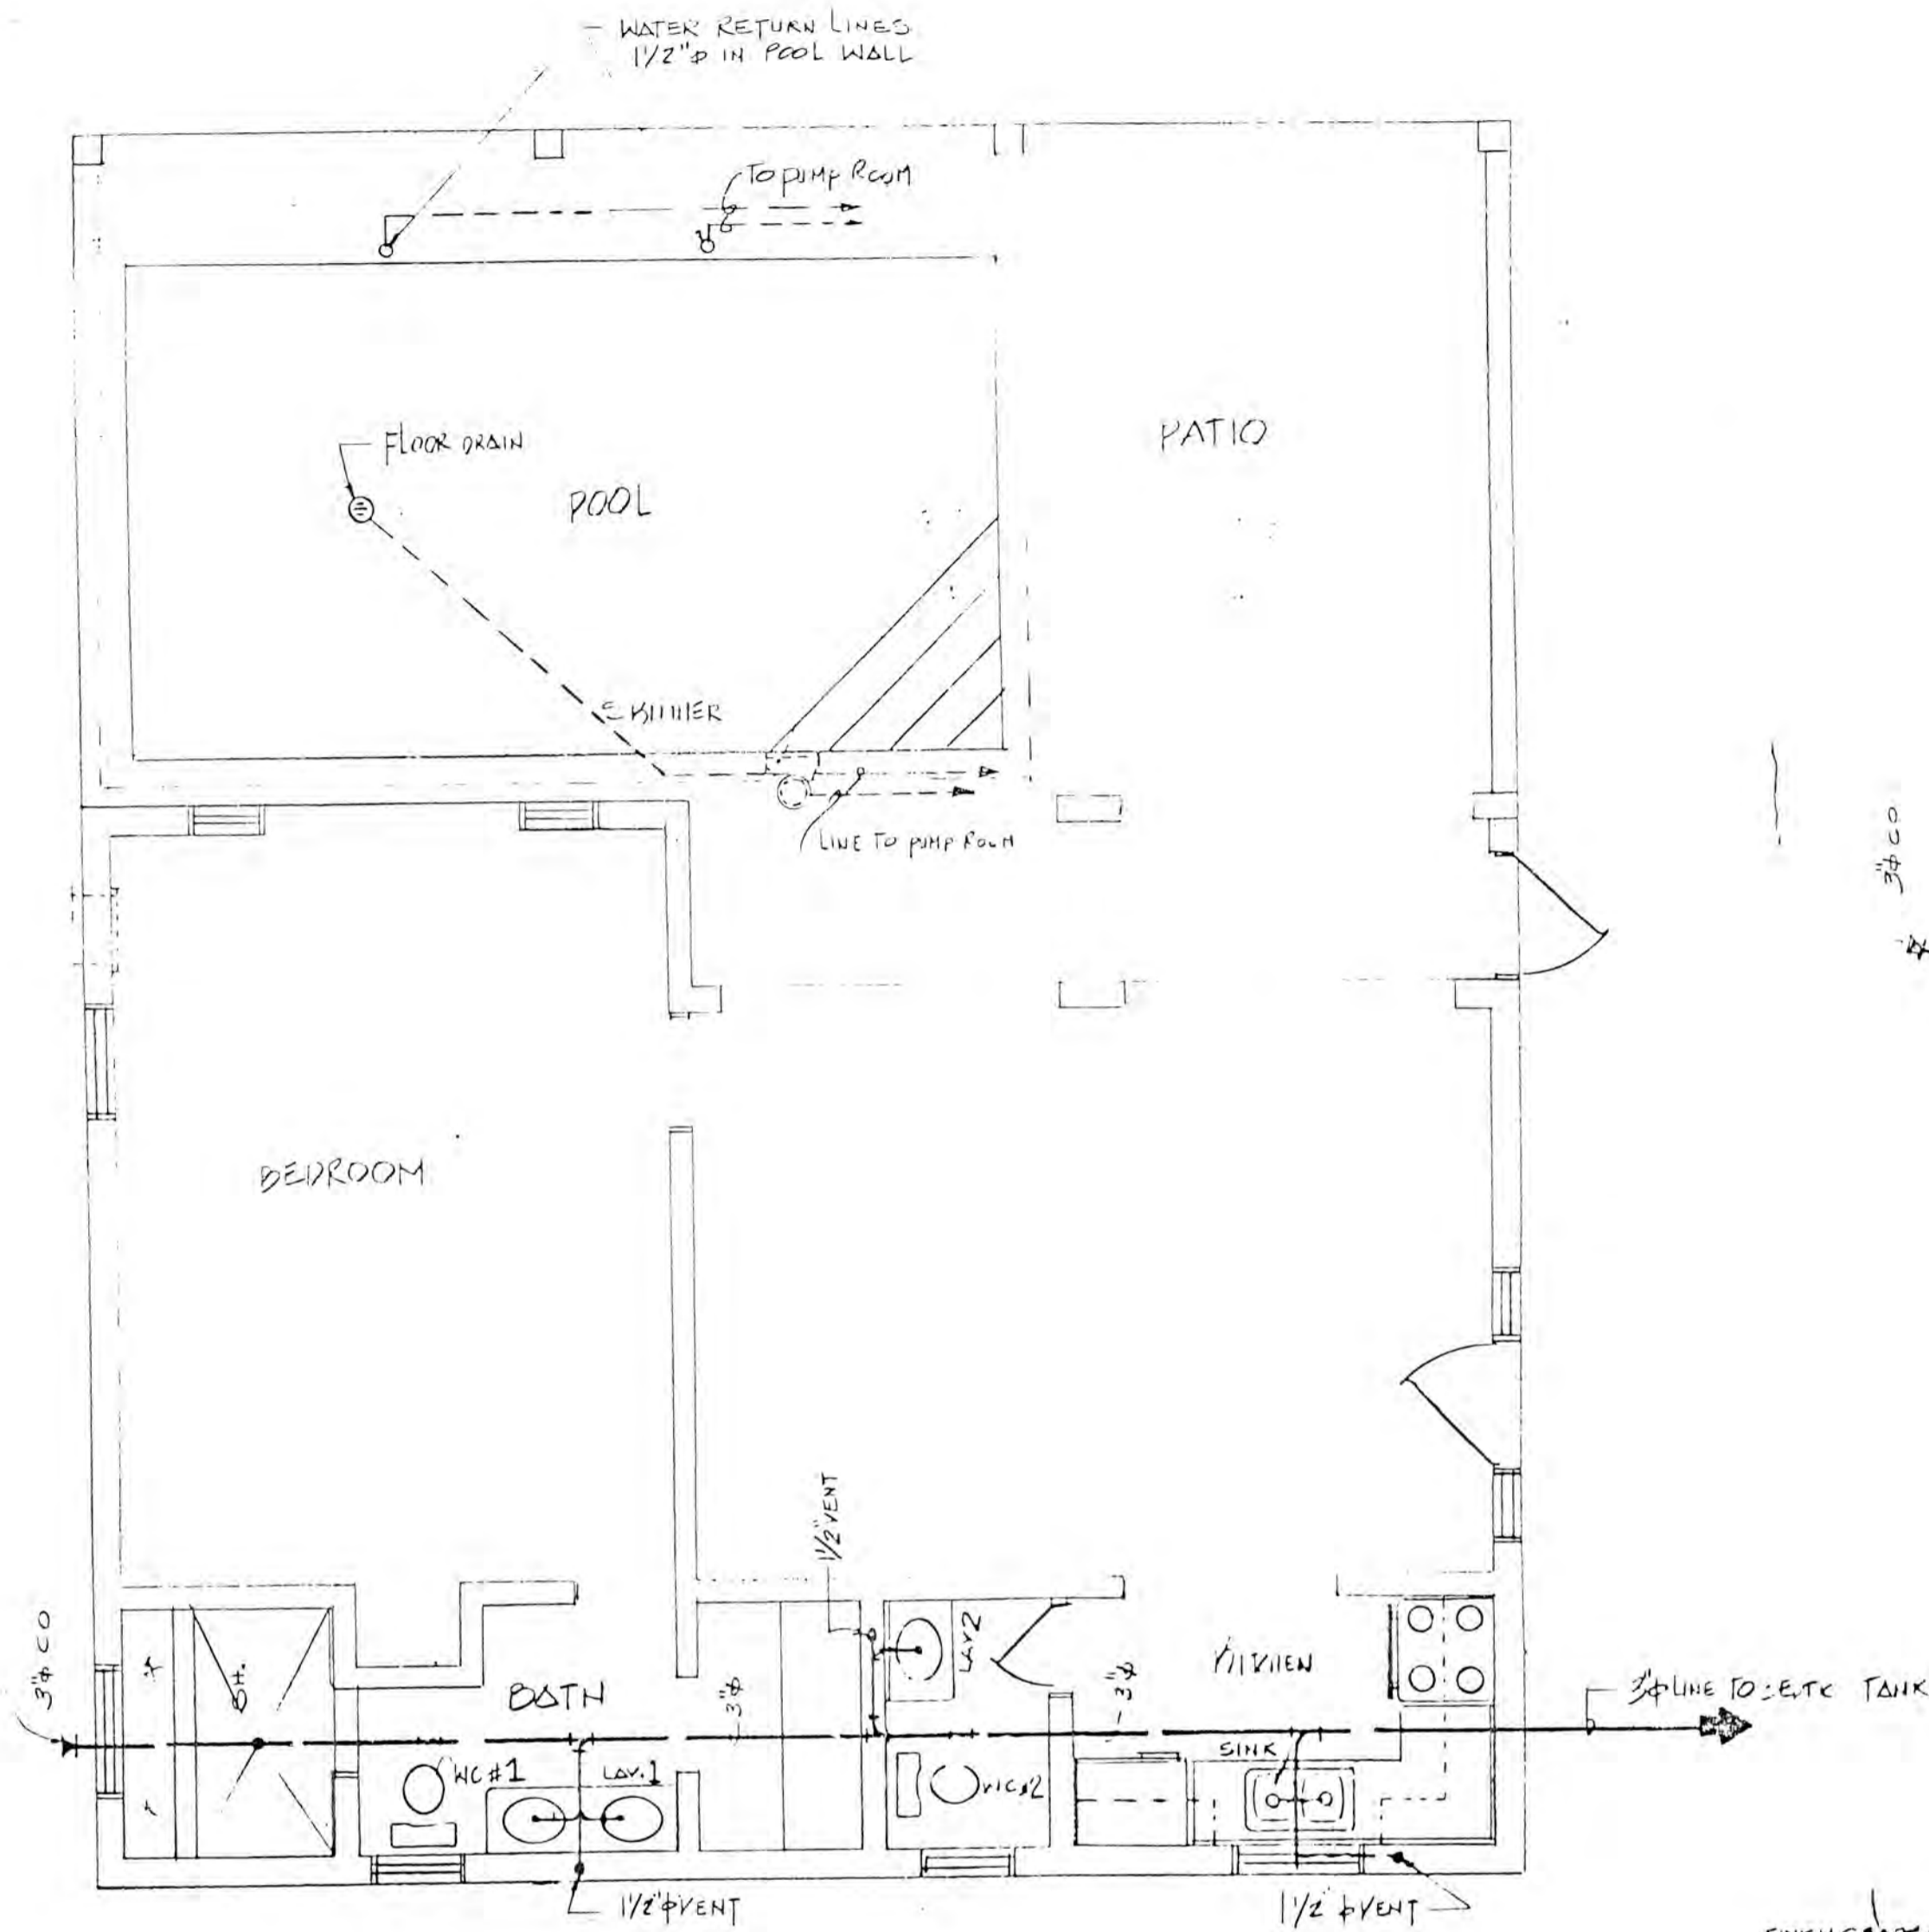


PLUMBING PLAN


1/4" = 1'-0"

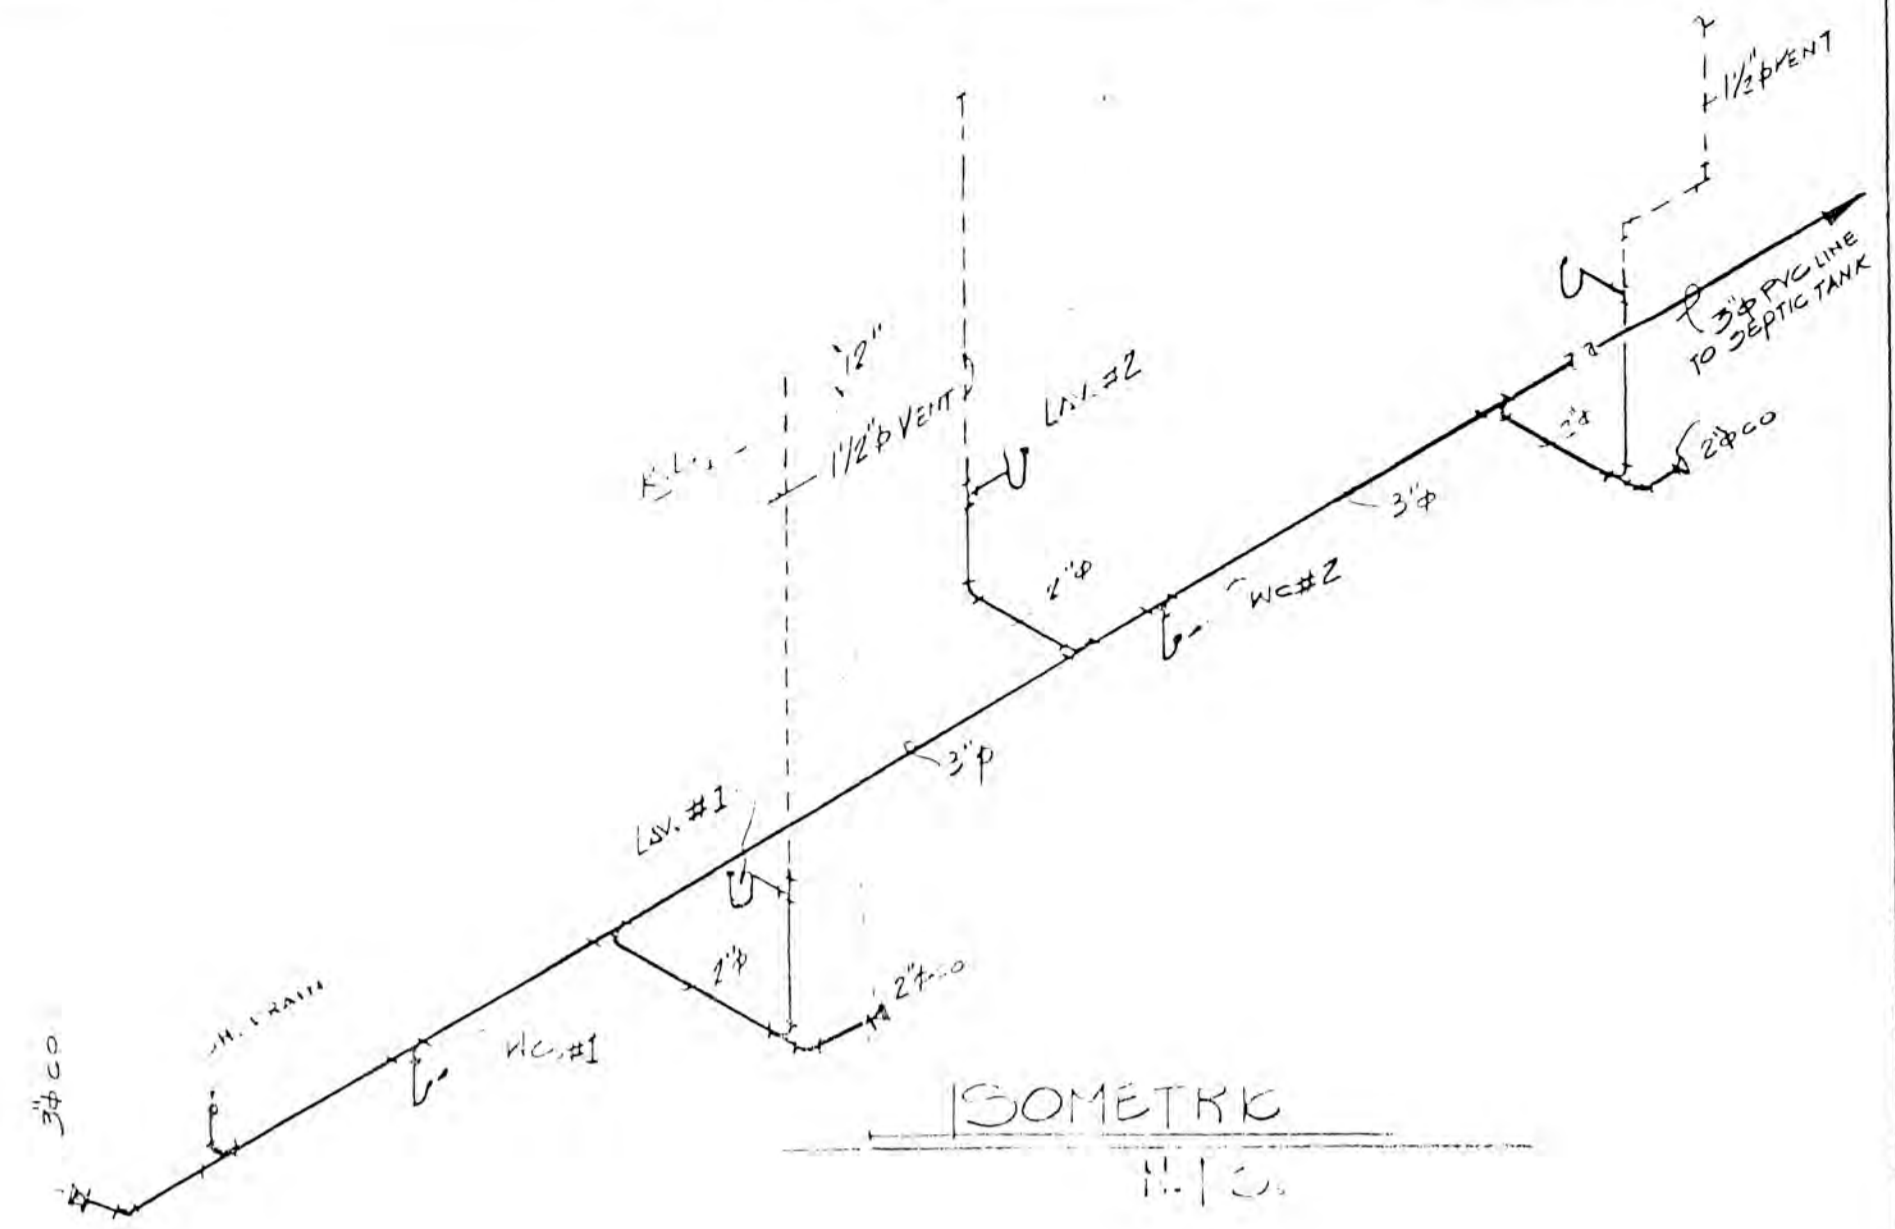

ISOMETRIC H.P.C.

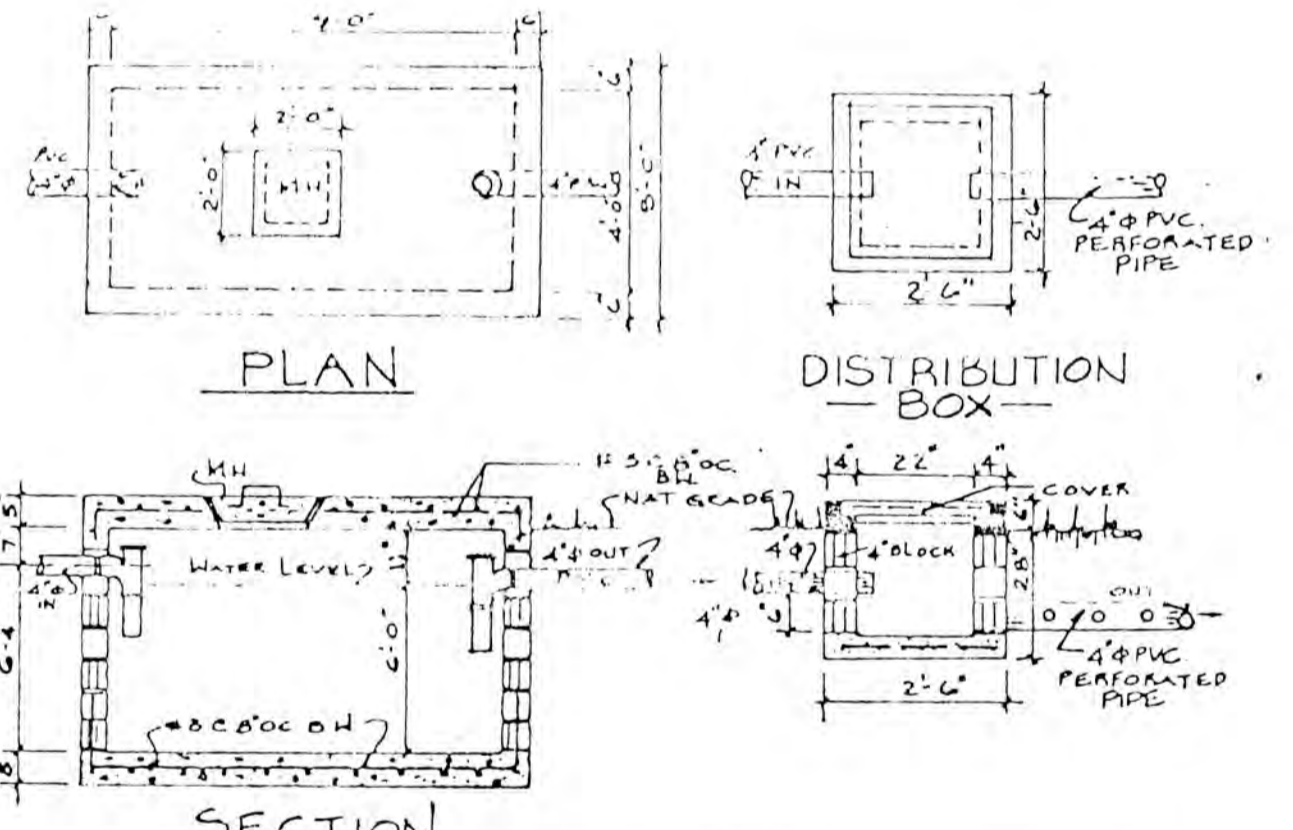

SEPTIC TANKS DETAILS

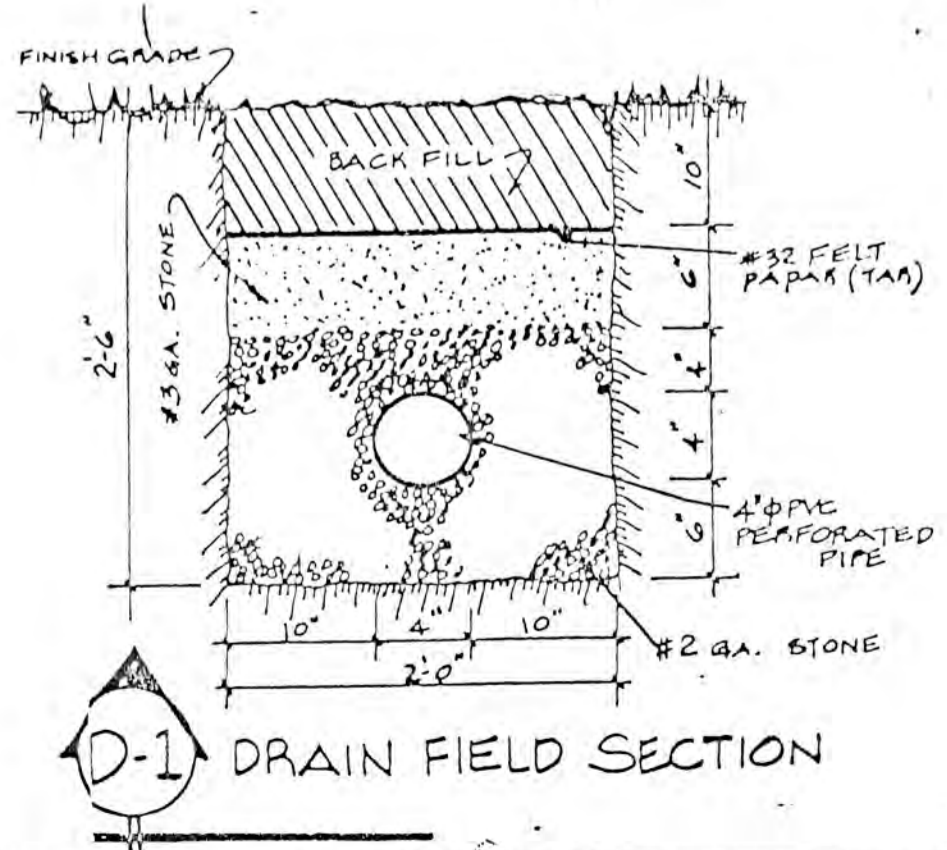

D-1 DRAIN FIELD SECTION



VILLA MADELEINE TEAGUE BAY STCROIX			
PLUMBING PLAN AND ISOMETRIC			
DRAWN BY CPAG	DATE.	SCALE: 1/4" = 1'-0"	SHEET NO. 11/11