

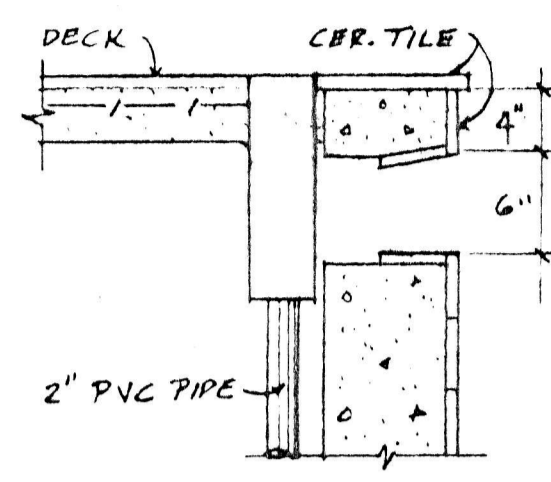


DETAIL "A"
SCALE 1" = 1'-0"

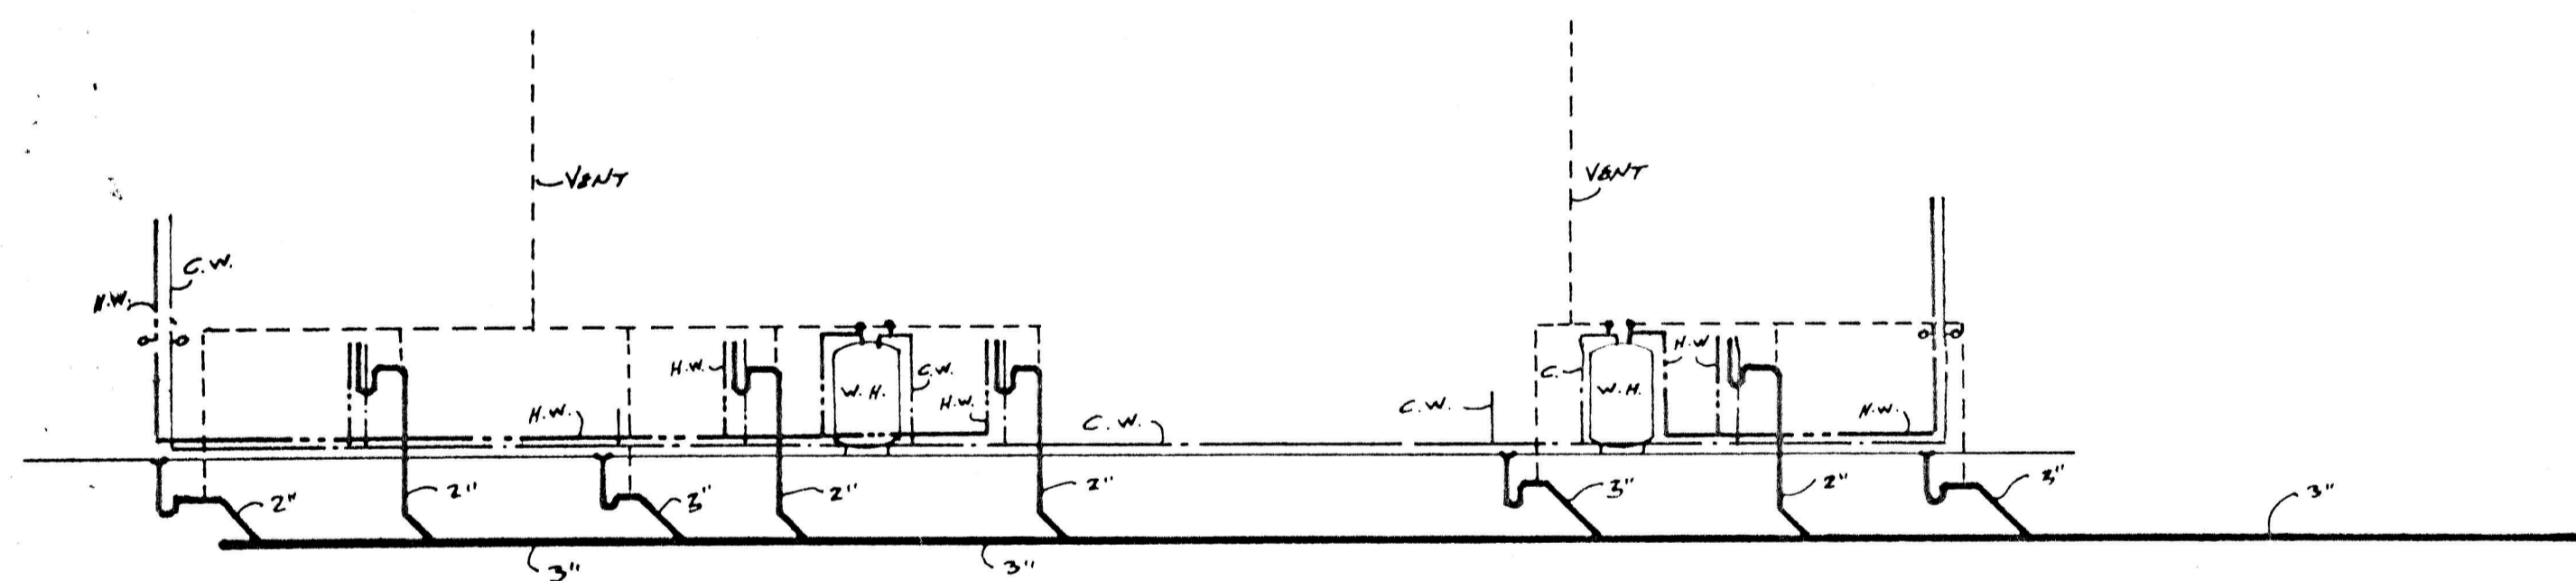


DETAIL "B"
SCALE 1" = 1'-0"

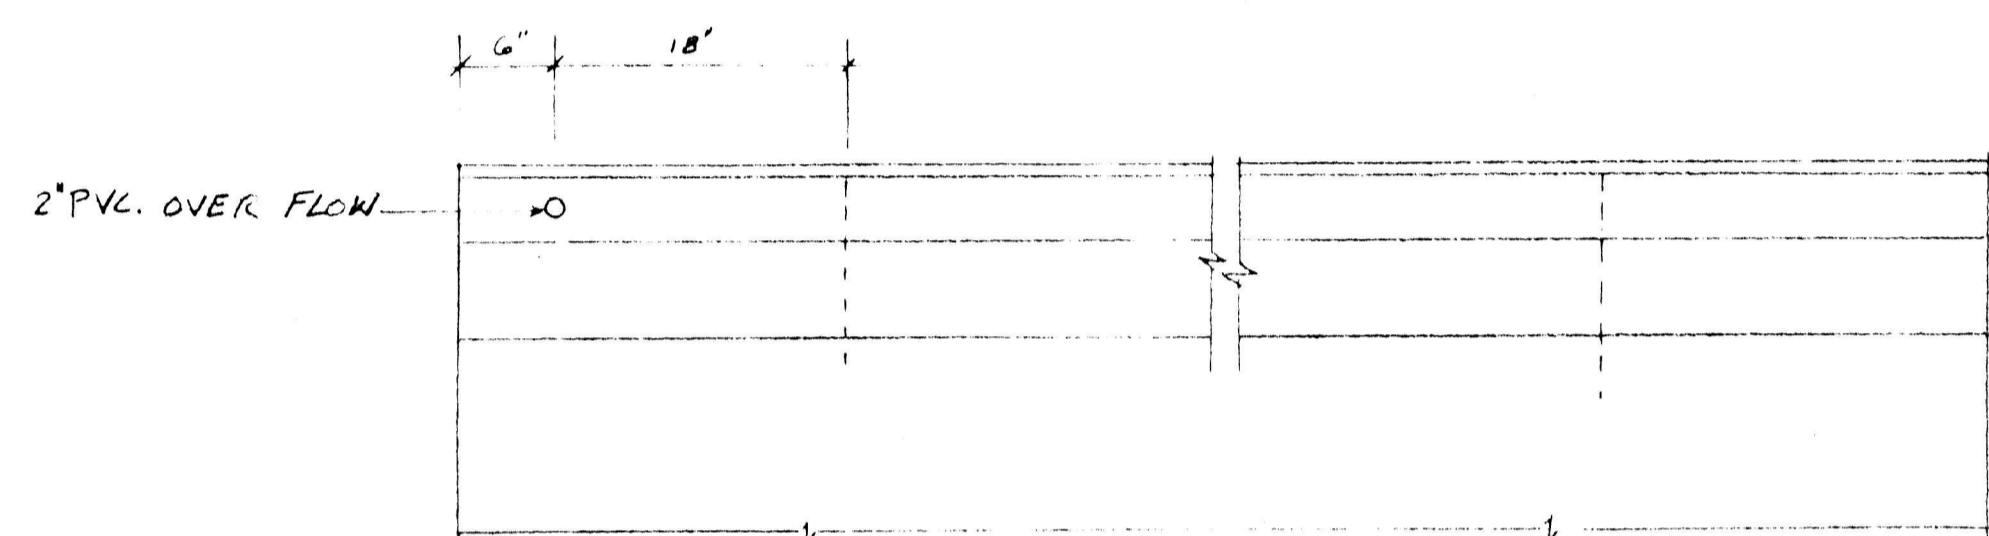

PLUMBING SECTION

SCALE 1/4" = 1'-0"

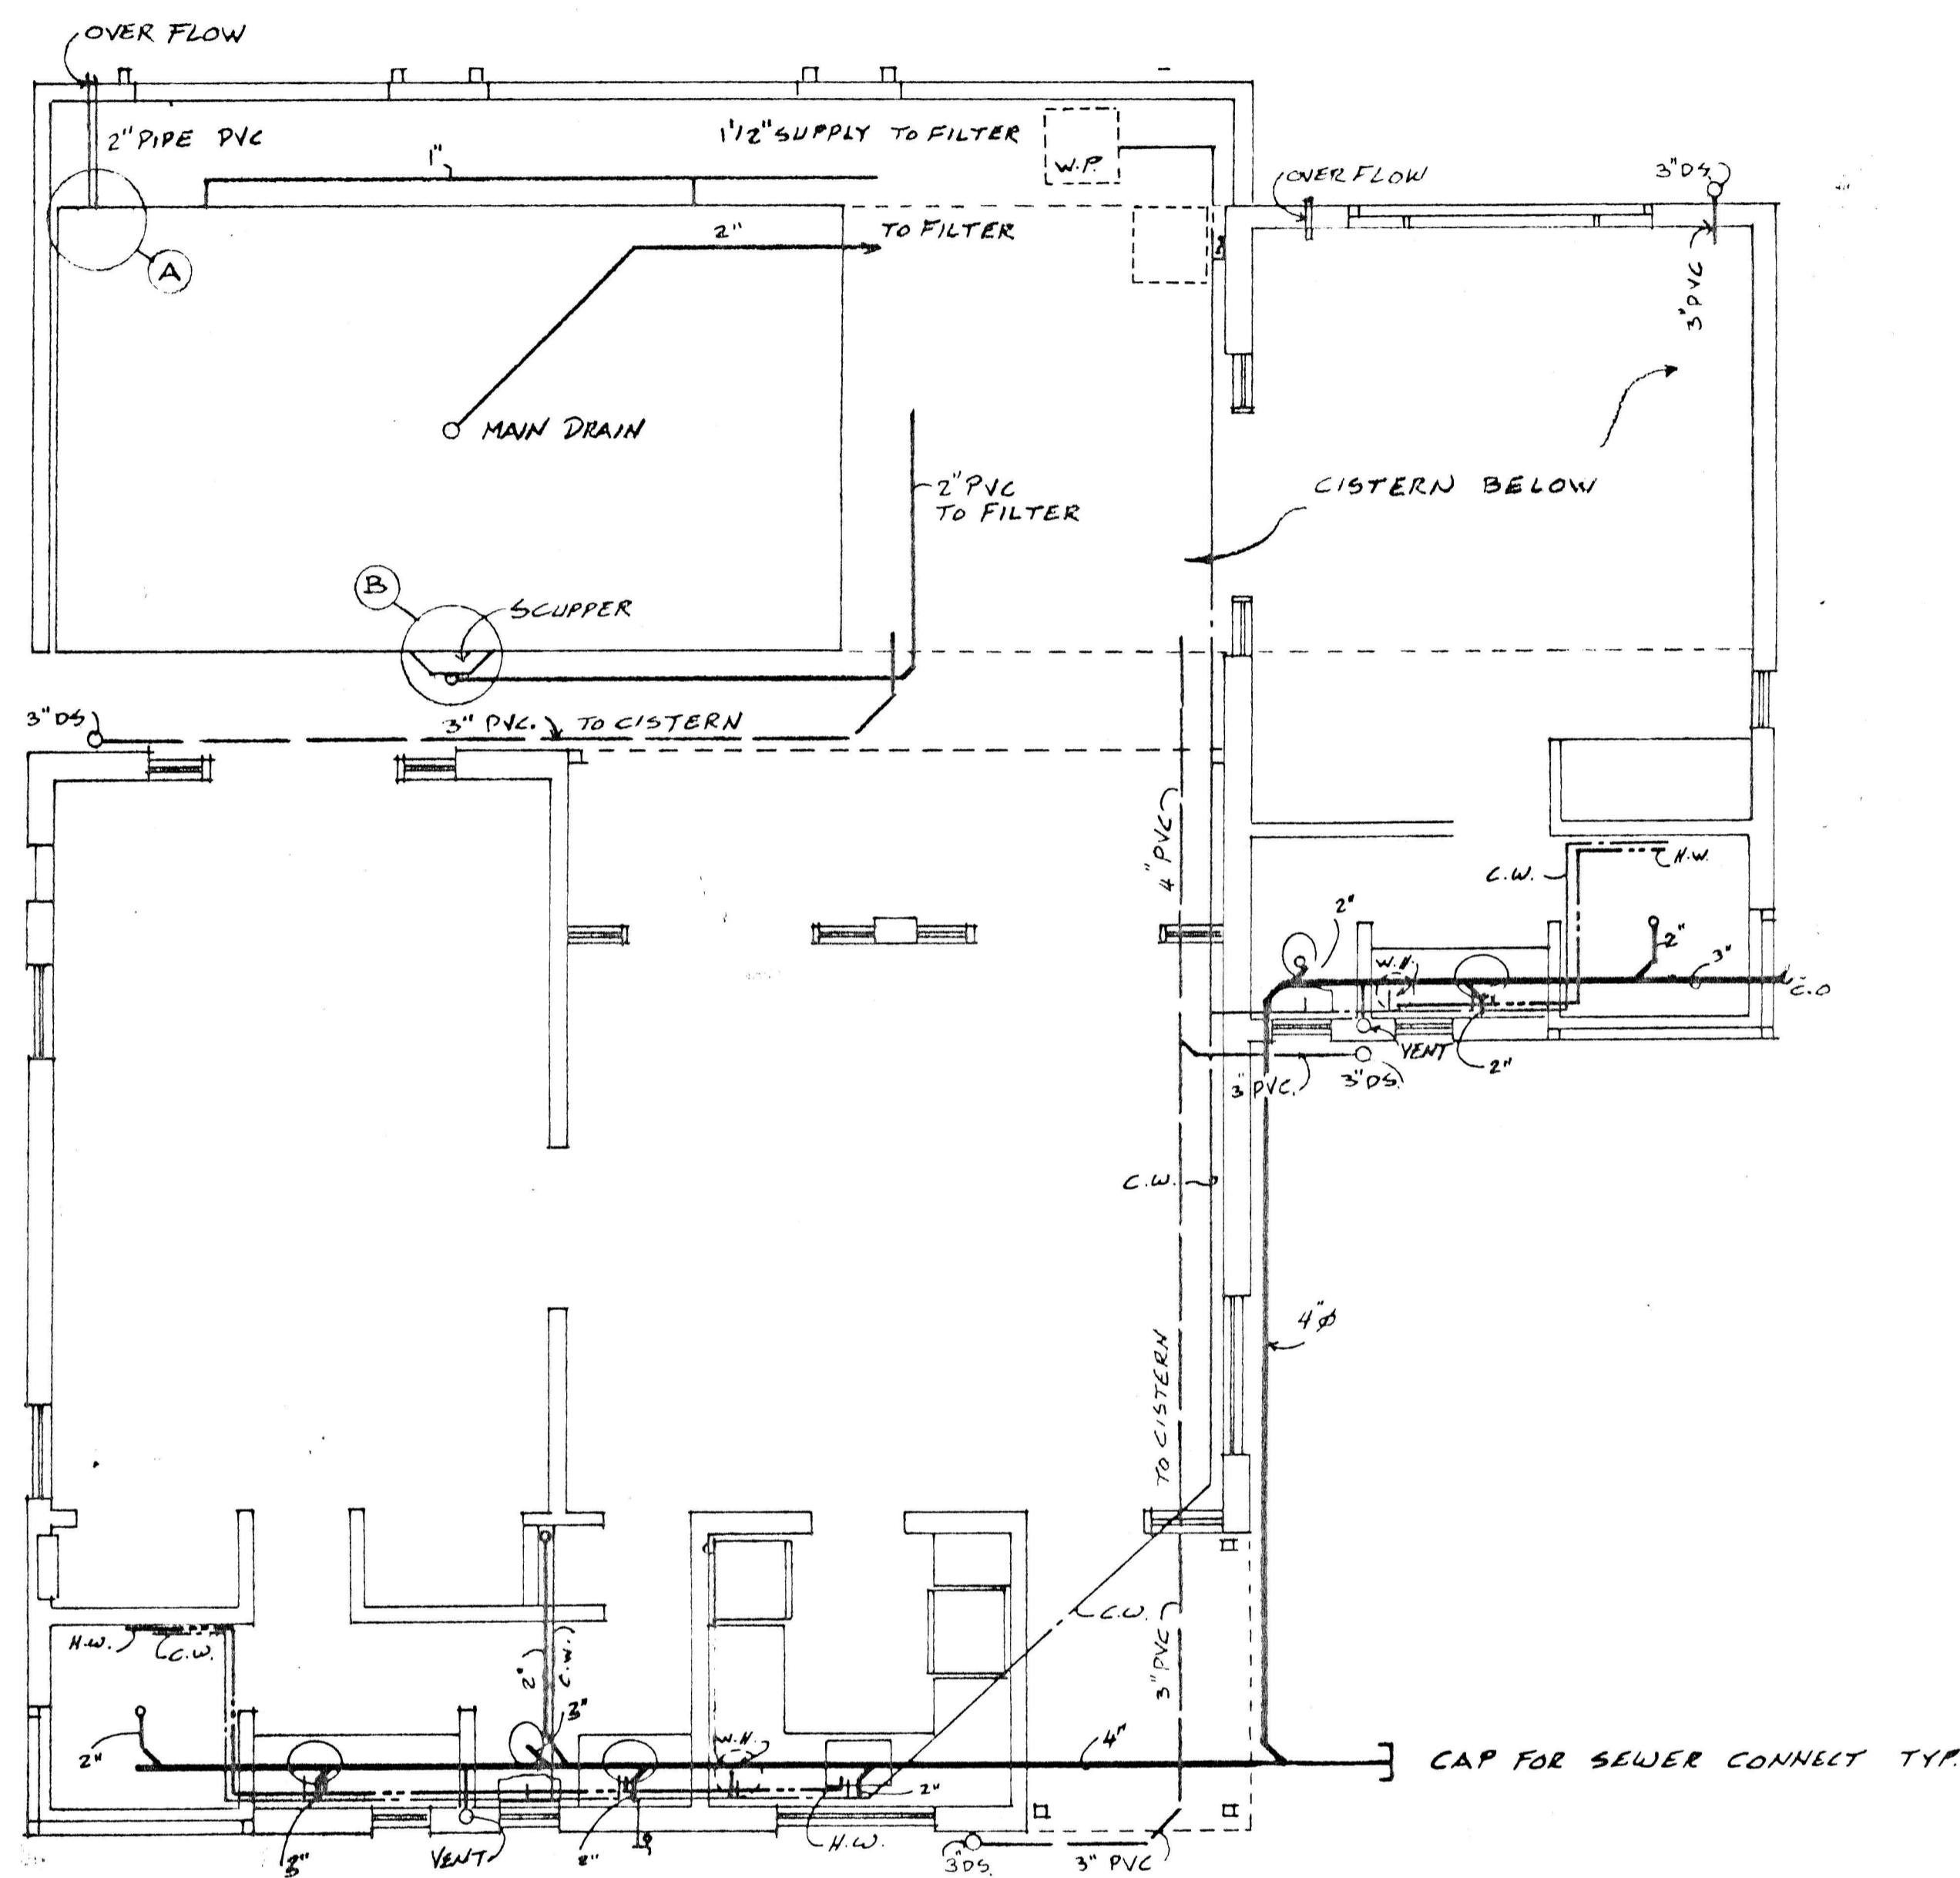

PLUMBING FLOOR PLAN

SCALE 1/4" = 1'-0"

CARIBBEAN CONSTRUCTION SERVICE & ASSOCIATES			
SCALE 1/4" = 1'-0"	APPROVED BY	DESIGNED BY	M.A.M.
DATE 6.29.1987		REVISED	
VILLA MADELEINE			DRAWING NUMBER
			P-2